
 


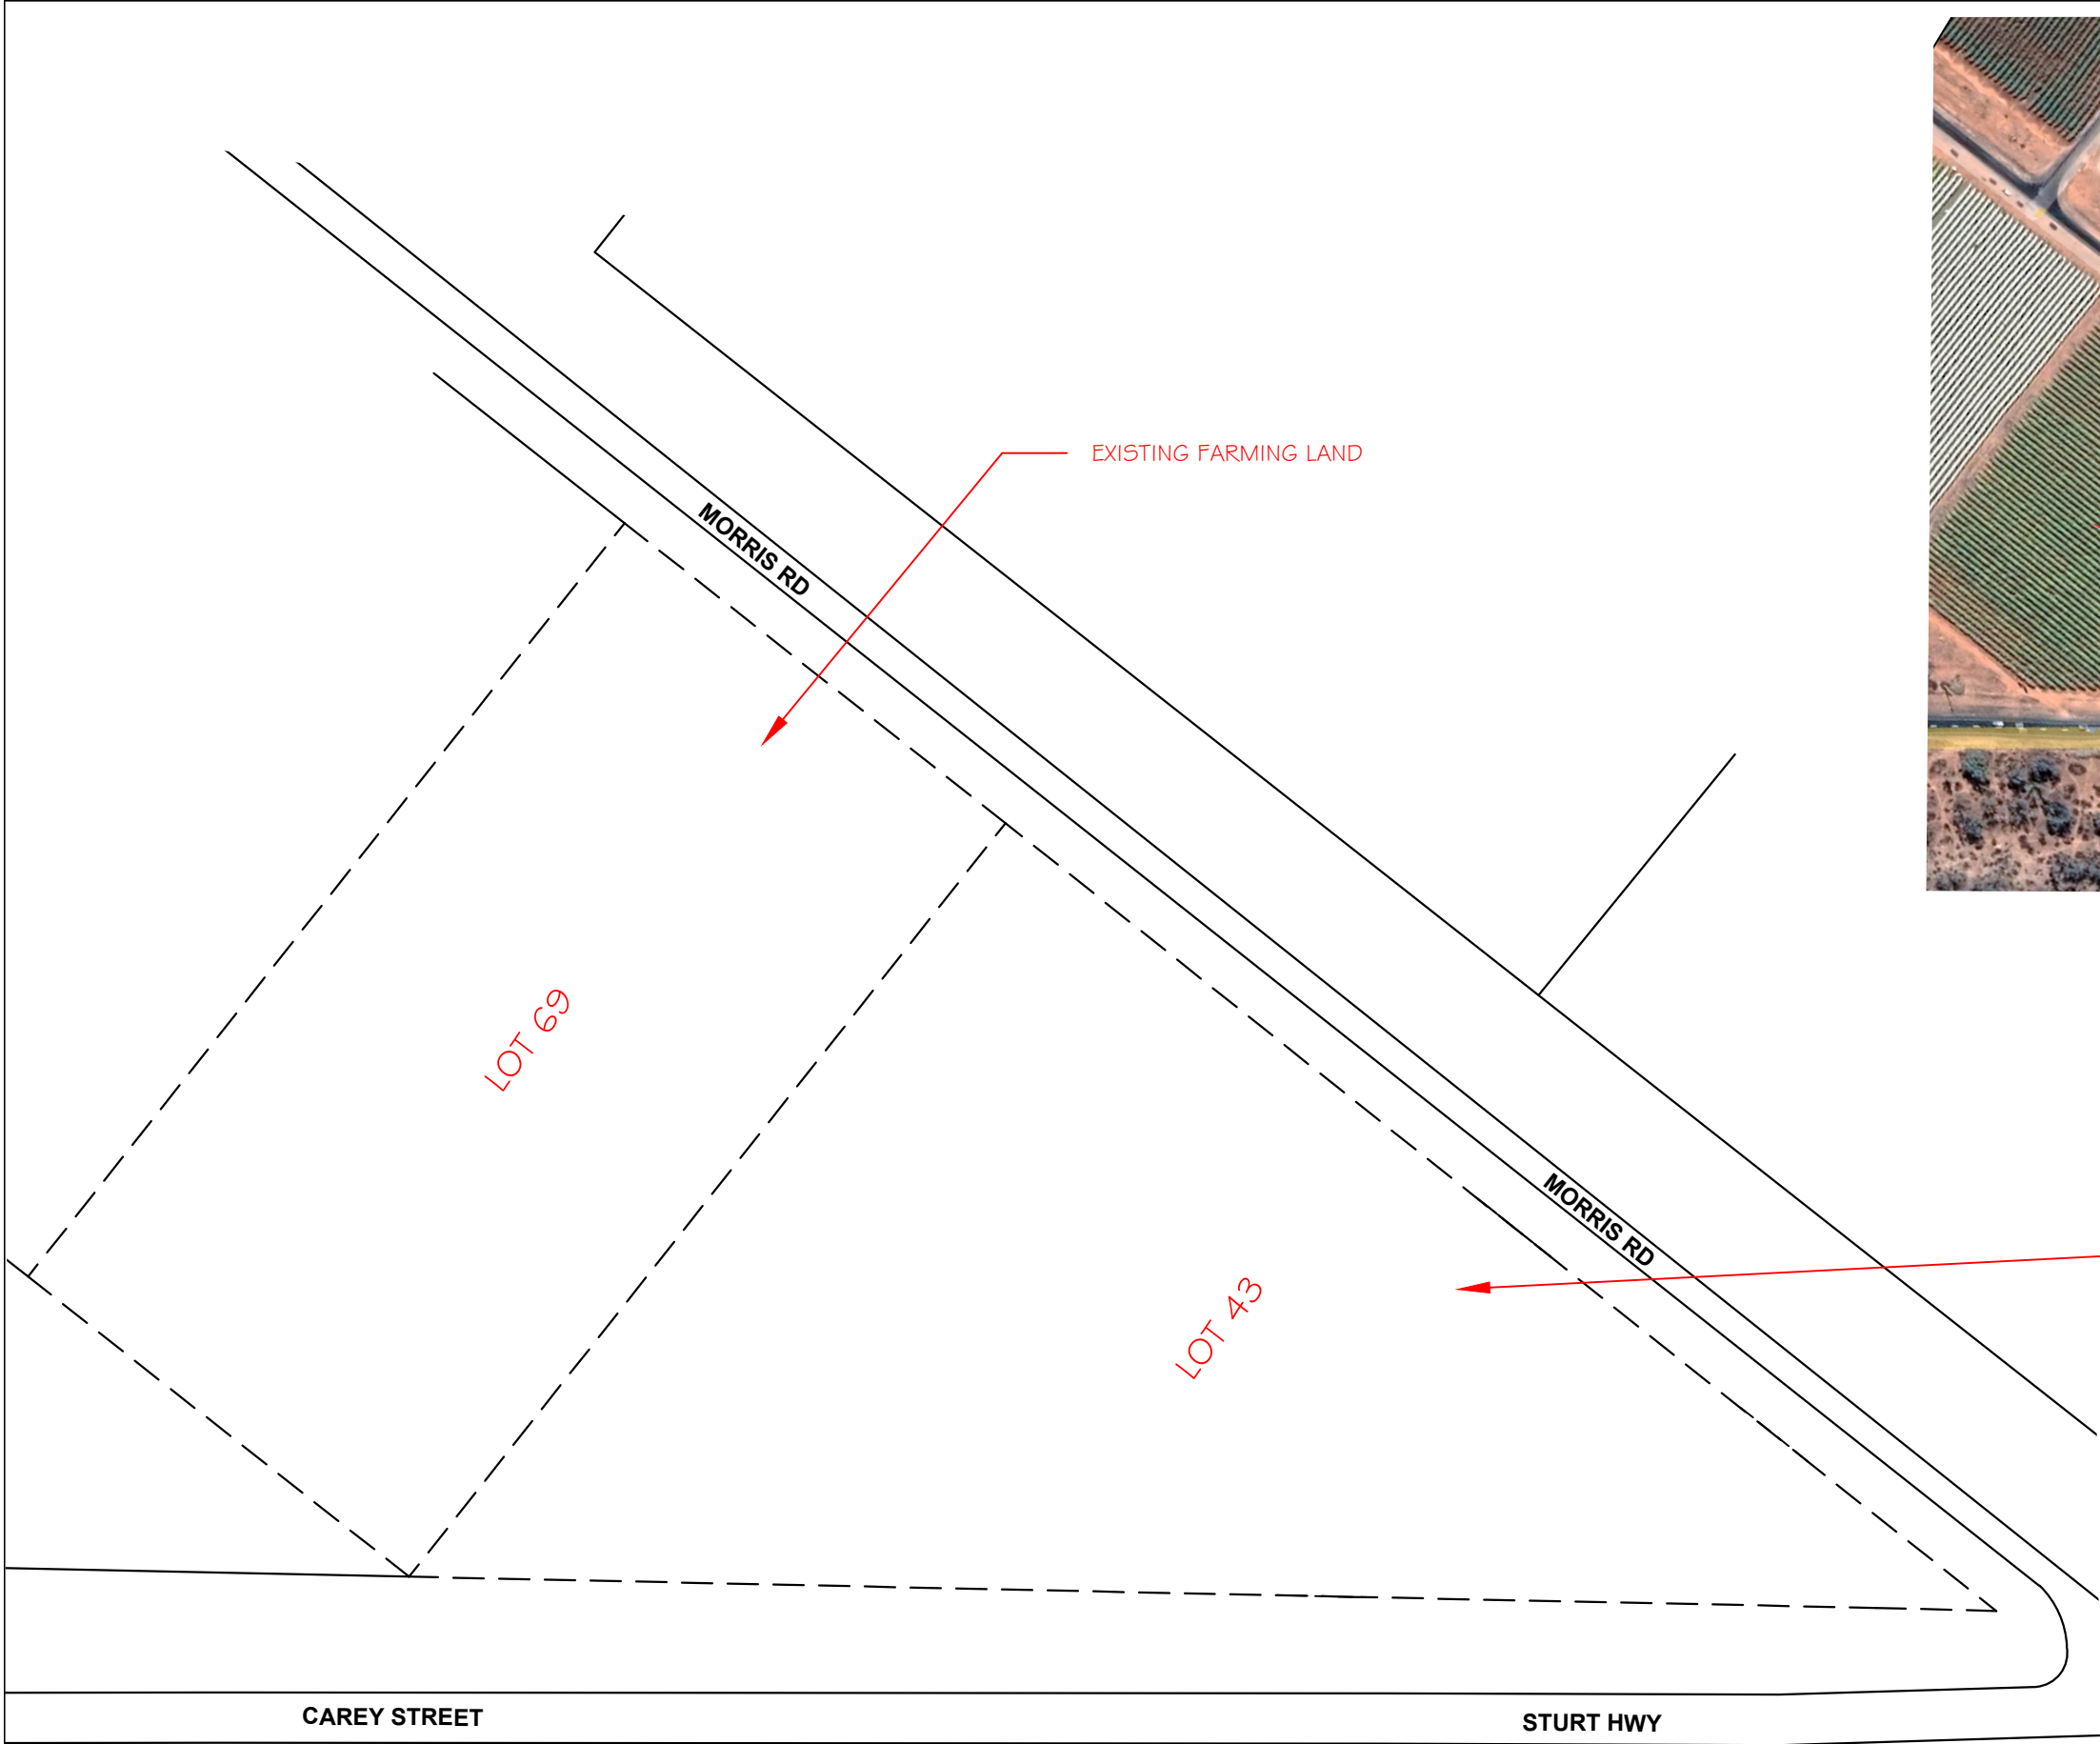

EXISTING LOCALITY LAYOUT
SCALE 1:2000 @ A1 / 1:4000 @ A3

EXISTING SITE LAYOUT
SCALE 1:1500 @ A1 / 1:3000 @ A3



DO NOT SCALE
DIMENSIONS IN MM
DRAWING PRACTICE
TO AS1100

DWG. No.	DATE	BY	REVISION/COMMENTS
1	17/11/22	TJB	ISSUED FOR COMMENT

BLACK DUCK DEVELOPMENTS		
MOB: 0412 149 167		
SUITE 6, 497 BURKE ROAD		
HAWTHORN EAST VIC 3123		
ABN : 68 086 502 838		
DRAWN DATE	DRAWN BY	CLIENT
NOV. 2022	TJB	SGH PETROLEUM

SGH PETROLEUM
CNR CAREY ST & MORRIS RD
EUSTON NSW 2737

EXISTING AND LOCALITY		
DRAWING No.	SIZE	REVISION
BD-SUNEUS-0800	A3	1

PRELIMINARY
NOT FOR CONSTRUCTION

FUEL SYSTEM DESIGN DRAWINGS

1. REFER TO ARCHIECTS DRAWINGS FOR EXISTING SITE LAYOUT AND PROPOSED DEMOLITION WORKS.

2. REFER TO LIBERTY STANDARDS FOR FUEL SYSTEM SCOPE OF WORKS

3. NEW FUEL SYSTEM DRAWINGS ENCLOSED:-
- BD-SUNEUS-0800

• BD-SUNEUS-0801

• BD-SUNEUS-0802

• BD-SUNEUS-3803

• BD-SUNEUS-0901

• BD-SUNEUS-0902

• BD-SUNEUS-0903

• BD-SUNEUS-0904

• BD-SUNEUS-1401

EXISTING SITE LAYOUT

PROPOSED SITE LAYOUT

PROPOSED SITE PLAN WITH EXISTING LEVELS

TANKER PATH LAYOUT

SITE LAYOUT - DETAILED

DETAIL - OFFICE/WAREHOUSE

DETAIL - CANOPY

DETAIL - TANK FARM

PROPOSED DRAINAGE LAYOUT

FUEL SYSTEM DESIGN WORKS

1. ALL FUEL SYSTEM WORKS COMPLETED BY AN EXPERIENCE, COMPETENT & ACCREDITED INSTALLER.
2. ALL WORKS COMPLETED TO:-


• SUNRAYSIA STANDARDS.

• A51940 AND A54897

• AS60079_10_1

TANK SCHEDULE				
TANK No	PRODUCT	PROD. CLASS	DESCRIPTION	TANK CAP's Ltrs
1	DSL	CLASS 3 PG II	U/G SELF BUNDED TANKS	110,000
2	DSL	CLASS 3 PG II	U/G SELF BUNDED TANKS	110,000
3	ULP	CLASS 3 PG II	U/G SELF BUNDED TANKS	55,000
4	ULP	COMBUSTIBLE C1	U/G SELF BUNDED TANKS	54,000
5	P98	CLASS 3 PG II	U/G SELF BUNDED TANKS	30,000
6	P95	CLASS 3 PG II	U/G SELF BUNDED TANKS	25,000
7	ADBLUE		A/G SELF BUNDED TANKS	5,000
8	SPEL	PURACEPTOR	U/G SELF BUNDED TANK	5,000


DISPENSER SCHEDULE			
No.	TYPE	PRODUCT	COMMENT
1/2	SANKI SK65 8 HOSE	ULP/P95 P98/DSL	NEW MPD REFER TO HOSE LOCATION ORDER
3/4	SANKI SK65 8 HOSE	ULP/P95 P98/DSL	NEW MPD REFER TO HOSE LOCATION ORDER
5/6	SANKI SK65 DUAL HOSE	ULP/P95 P98/DSL	NEW MPD REFER TO HOSE LOCATION ORDER
7/8	SANKI SK52 DUAL HOSE	DSL/ADB	NEW MPD - 110 LPM REFER TO HOSE LOCATION ORDER
9/10	SANKI SK52 DUAL HOSE	DSL/ADB	NEW MPD - 110 LPM REFER TO HOSE LOCATION ORDER
11/12	SANKI SK52 DUAL HOSE	DSL/ADB	NEW MPD - 110 LPM REFER TO HOSE LOCATION ORDER

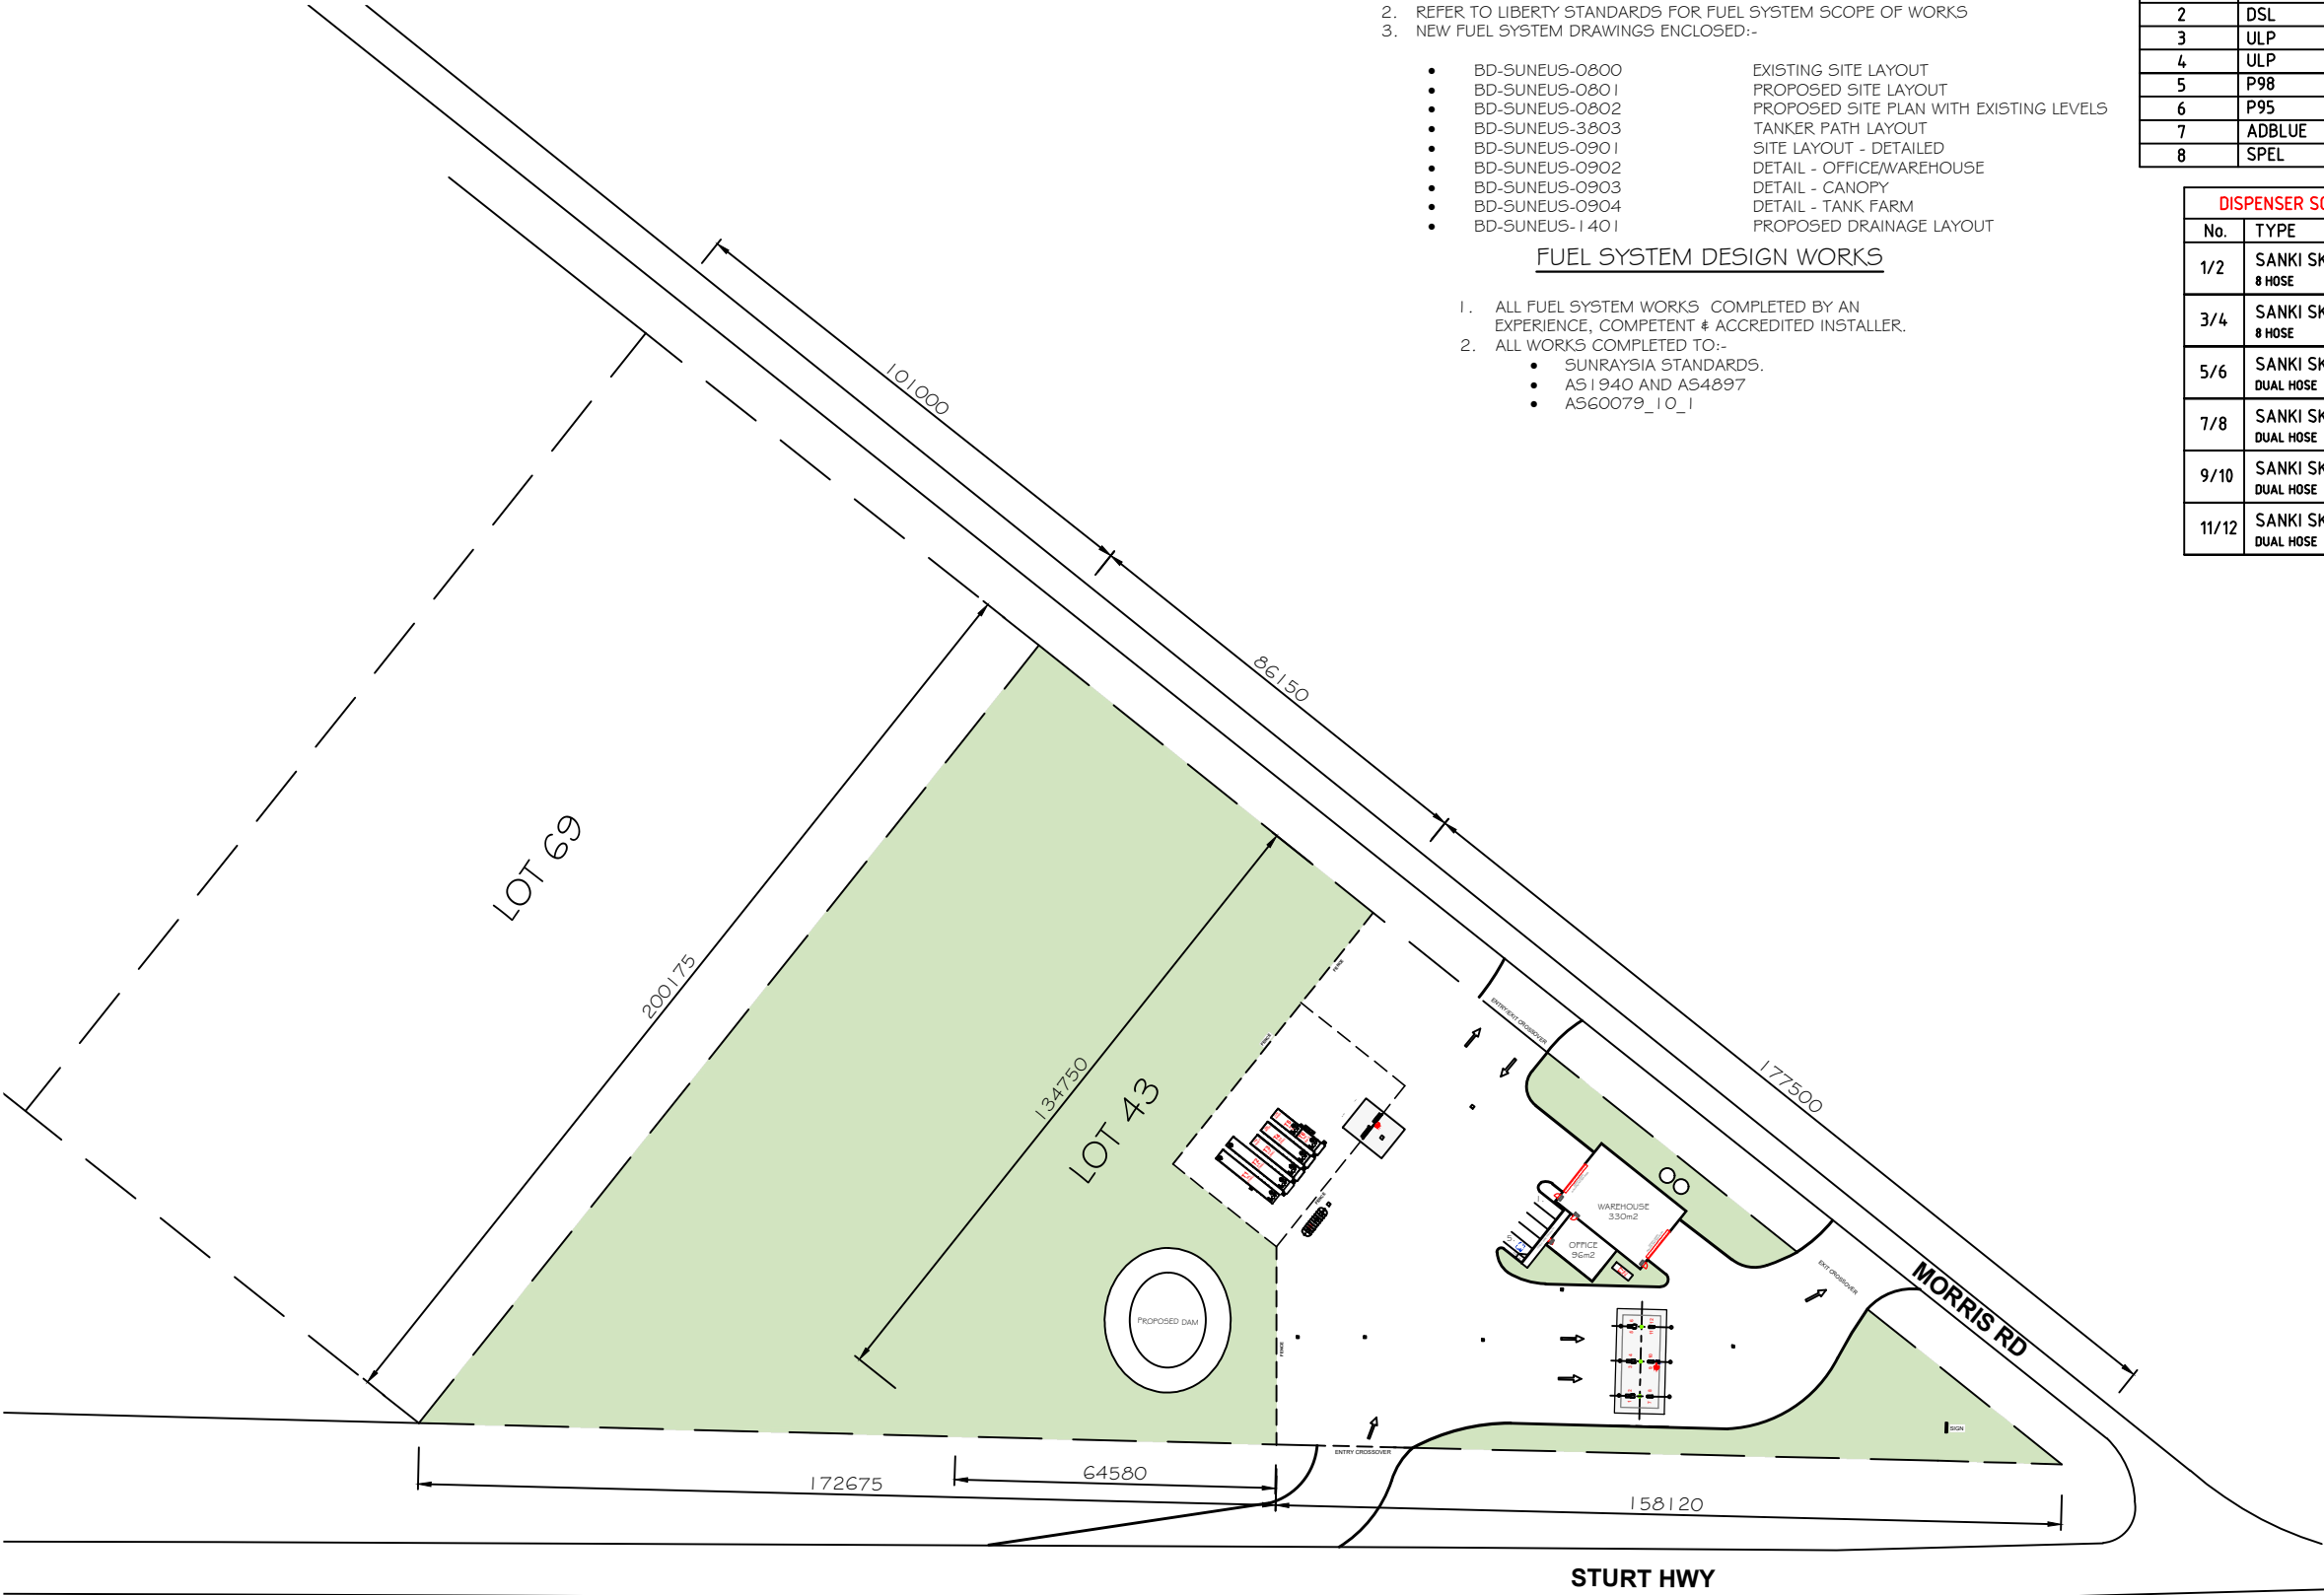


PROPOSED SITE LAYOUT

SCALE 1:1500 @ A1 / 1:3000 @ A3

 PRELIMINARY
NOT FOR CONSTRUCTION



	DO NOT SCALE DIMENSIONS IN MM DRAWING PRACTICE TO AS1100				BLACK DUCK DEVELOPMENTS MOB: 0412 149 167 SUITE 6, 497 BURKE ROAD HAWTHORN EAST VIC 3123 ABN : 68 086 502 838				SGH PETROLEUM CNR CAREY ST & MORRIS RD EUSTON NSW 2737				PROPOSED SITE LAYOUT									
				1	17/1 1/22	TJB	ISSUED FOR COMMENT															
				DWG No.	DATE	BY	REVISION/COMMENTS				DRAWN DATE		DRAWN BY		CLIENT		DRAWING No.		SIZE		REVISION	
											NOV. 2022		TJB		SGH PETROLEUM		BD-SUNEUS-0801		A3		1	

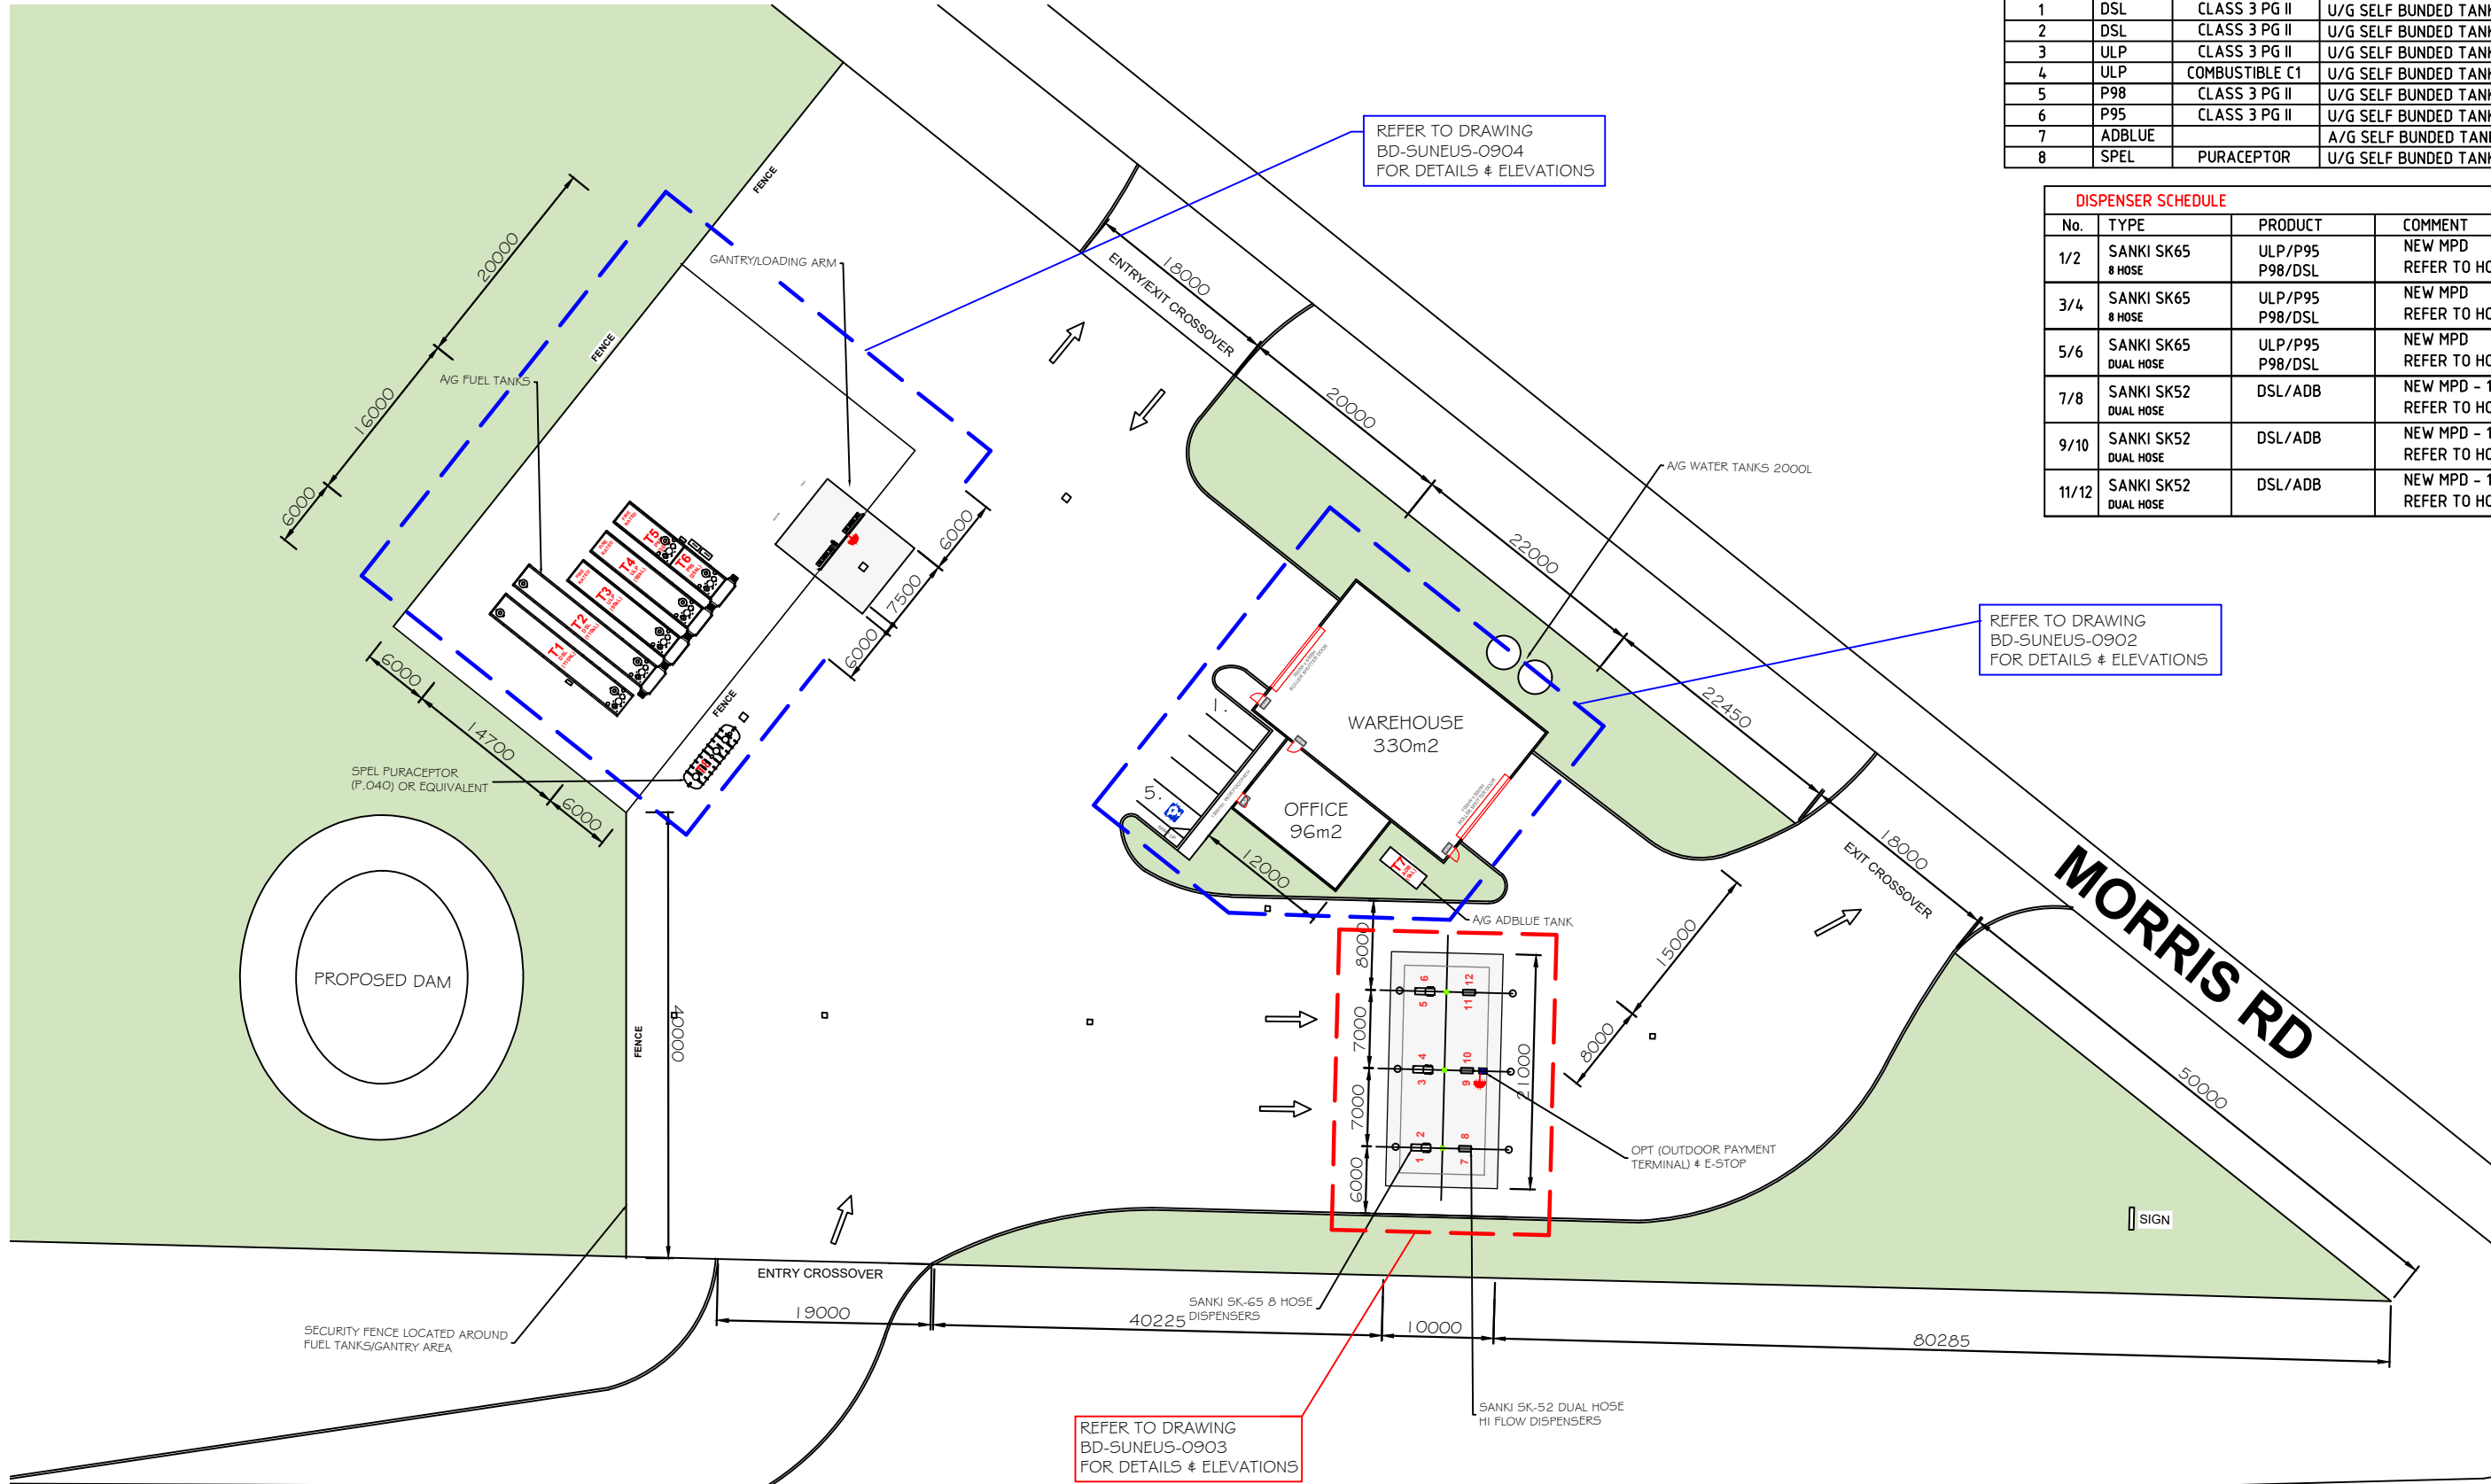


TANK SCHEDULE				
TANK No	PRODUCT	PROD. CLASS	DESCRIPTION	TANK CAP's Ltrs
1	DSL	CLASS 3 PG II	U/G SELF BUNDED TANKS	110,000
2	DSL	CLASS 3 PG II	U/G SELF BUNDED TANKS	110,000
3	ULP	CLASS 3 PG II	U/G SELF BUNDED TANKS	55,000
4	ULP	COMBUSTIBLE C1	U/G SELF BUNDED TANKS	54,000
5	P98	CLASS 3 PG II	U/G SELF BUNDED TANKS	30,000
6	P95	CLASS 3 PG II	U/G SELF BUNDED TANKS	25,000
7	ADBLUE		A/G SELF BUNDED TANKS	5,000
8	SPEL	PURCEPTOR	U/G SELF BUNDED TANK	5,000

DISPENSER SCHEDULE			
No.	TYPE	PRODUCT	COMMENT
1/2	SANKI SK65 8 HOSE	ULP/P95 P98/DSL	NEW MPD REFER TO HOSE LOCATION ORDER
3/4	SANKI SK65 8 HOSE	ULP/P95 P98/DSL	NEW MPD REFER TO HOSE LOCATION ORDER
5/6	SANKI SK65 DUAL HOSE	ULP/P95 P98/DSL	NEW MPD REFER TO HOSE LOCATION ORDER
7/8	SANKI SK52 DUAL HOSE	DSL/ADB	NEW MPD - 110 LPM REFER TO HOSE LOCATION ORDER
9/10	SANKI SK52 DUAL HOSE	DSL/ADB	NEW MPD - 110 LPM REFER TO HOSE LOCATION ORDER
11/12	SANKI SK52 DUAL HOSE	DSL/ADB	NEW MPD - 110 LPM REFER TO HOSE LOCATION ORDER

STURT HWY

SITE LAYOUT - DETAIL

 SCALE 1:600 @ A3



DO NOT SCALE
DIMENSIONS IN MM
DRAWING PRACTICE
TO AS1100


DWG No.	DATE	BY	REVISION/COMMENTS
1	17/11/22	TJB	ISSUED FOR COMMENT

BLACK DUCK DEVELOPMENTS MOB: 0412 149 167 SUITE 6, 497 BURKE ROAD HAWTHORN EAST VIC 3123 ABN : 68 086 502 838		
DRAWN DATE NOV. 2022	DRAWN BY TJB	CLIENT SGH PETROLEUM

SGH PETROLEUM
CNR CAREY ST & MORRIS RD
EUSTON NSW 2737


SITE LAYOUT - DETAIL		
DRAWING No. BD-SUNEUS-0901	SIZE A3	REVISION 1

PRELIMINARY
NOT FOR CONSTRUCTION

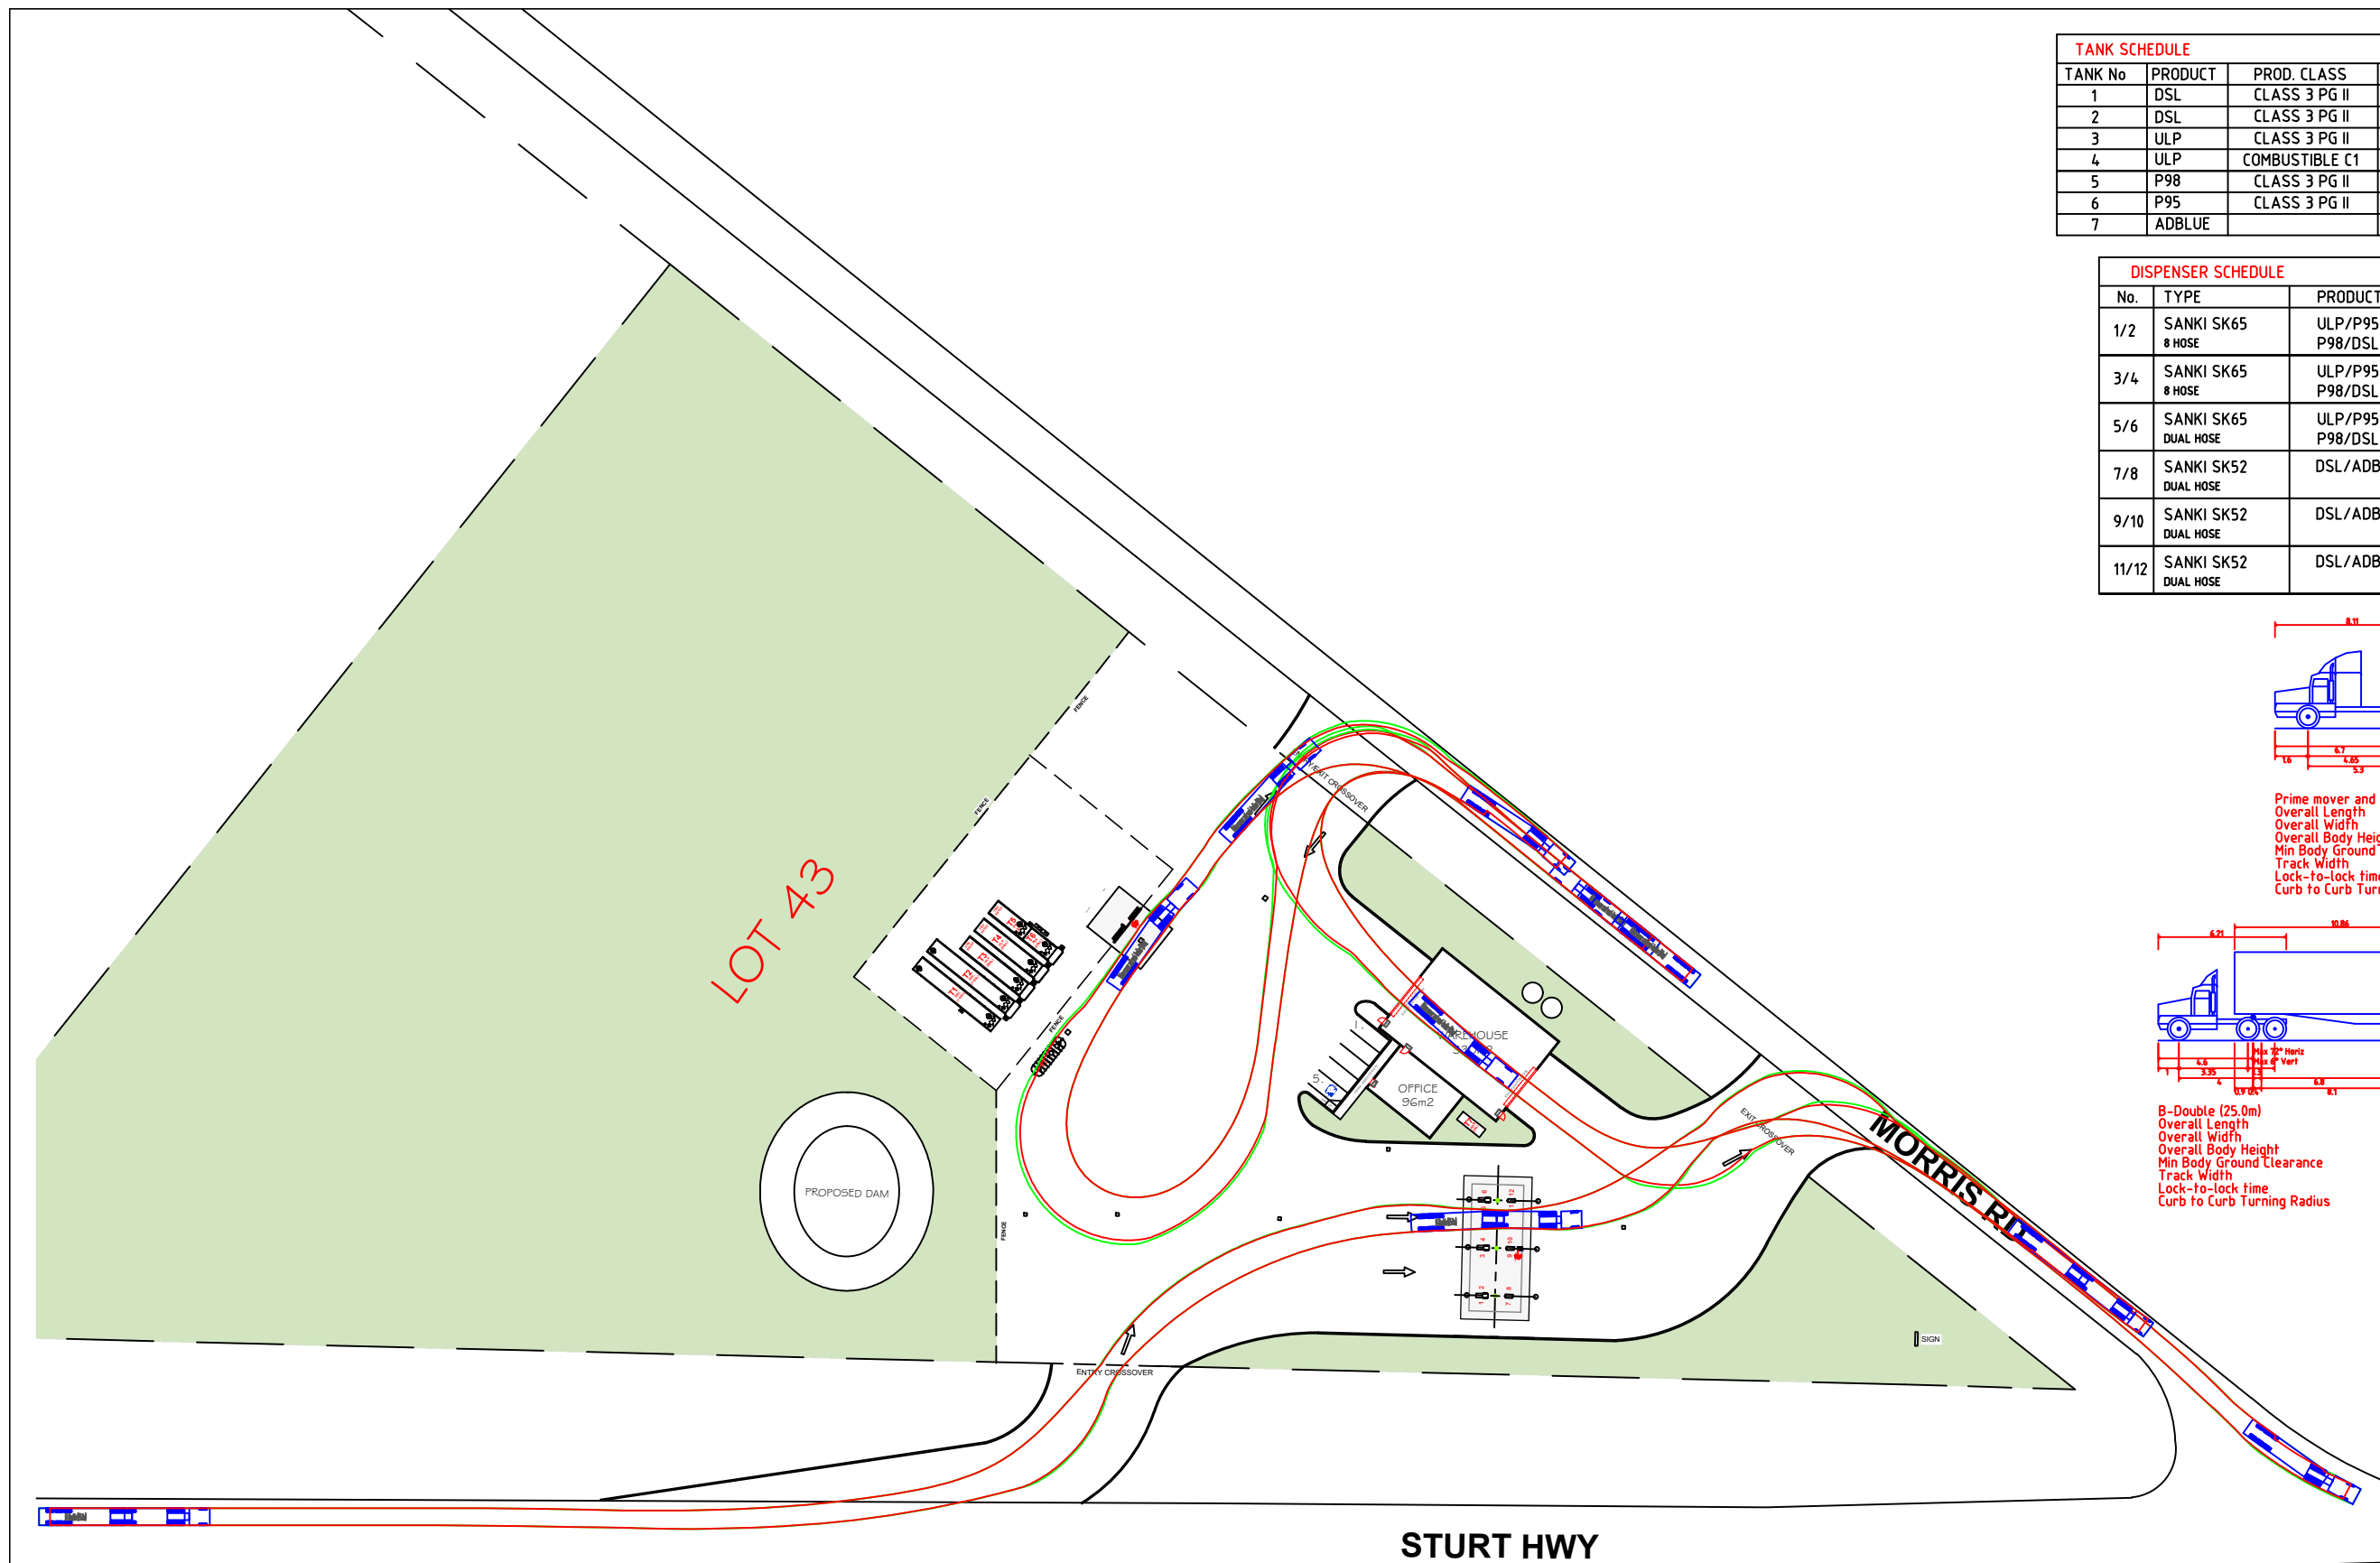


TANK SCHEDULE				
TANK No	PRODUCT	PROD. CLASS	DESCRIPTION	TANK CAP's Ltrs
1	DSL	CLASS 3 PG II	U/G SELF BUNDED TANKS	110,000
2	DSL	CLASS 3 PG II	U/G SELF BUNDED TANKS	110,000
3	ULP	CLASS 3 PG II	U/G SELF BUNDED TANKS	55,000
4	ULP	COMBUSTIBLE C1	U/G SELF BUNDED TANKS	54,000
5	P98	CLASS 3 PG II	U/G SELF BUNDED TANKS	30,000
6	P95	CLASS 3 PG II	U/G SELF BUNDED TANKS	25,000
7	ADBLUE		A/G SELF BUNDED TANKS	5,000

DISPENSER SCHEDULE			
No.	TYPE	PRODUCT	COMMENT
1/2	SANKI SK65 8 HOSE	ULP/P95 P98/DSL	NEW MPD REFER TO HOSE LOCATION ORDER
3/4	SANKI SK65 8 HOSE	ULP/P95 P98/DSL	NEW MPD REFER TO HOSE LOCATION ORDER
5/6	SANKI SK65 DUAL HOSE	ULP/P95 P98/DSL	NEW MPD REFER TO HOSE LOCATION ORDER
7/8	SANKI SK52 DUAL HOSE	DSL/ADB	NEW MPD - 110 LPM REFER TO HOSE LOCATION ORDER
9/10	SANKI SK52 DUAL HOSE	DSL/ADB	NEW MPD - 110 LPM REFER TO HOSE LOCATION ORDER
11/12	SANKI SK52 DUAL HOSE	DSL/ADB	NEW MPD - 110 LPM REFER TO HOSE LOCATION ORDER

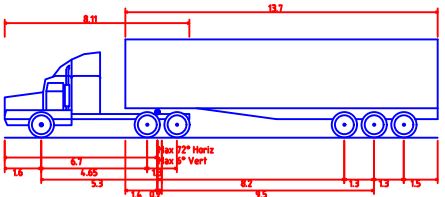

Prime mover and semi-trailer (19 m)
Overall Length 19.000m
Overall Width 2.500m
Overall Body Height 4.300m
Min Body Ground Clearance 0.540m
Track Width 2.500m
Lock-to-lock time 6.00s
Curb to Curb Turning Radius 12.500m

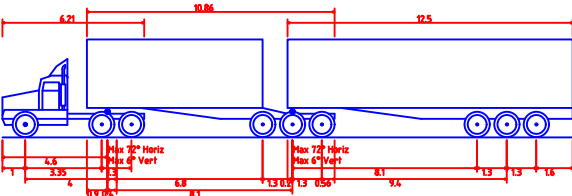


B-Double (25.0m)
Overall Length 25.000m
Overall Width 2.500m
Overall Body Height 4.300m
Min Body Ground Clearance 0.540m
Track Width 2.500m
Lock-to-lock time 6.00s
Curb to Curb Turning Radius 15.000m

TANKER PATH LAYOUT

SCALE 1:1000 @ A3

 PRELIMINARY
NOT FOR CONSTRUCTION




DO NOT SCALE DIMENSIONS IN MM DRAWING PRACTICE TO AS1100					
	DWG No.	1	17/11/22	TJB	ISSUED FOR COMMENT
	DATE	BY	REVISION/COMMENTS		

BLACK DUCK DEVELOPMENTS		
MOB: 0412 149 167 SUITE 6, 497 BURKE ROAD HAWTHORN EAST VIC 3123		
DRAWN DATE NOV. 2022	DRAWN BY TJB	CLIENT SGH PETROLEUM

SGH PETROLEUM	
CNR CAREY ST & MORRIS RD	
EUSTON NSW 2737	

TANKER PATH LAYOUT		
DRAWING No.	SIZE	REVISION
BD-SUNEUS-0803	A3	1

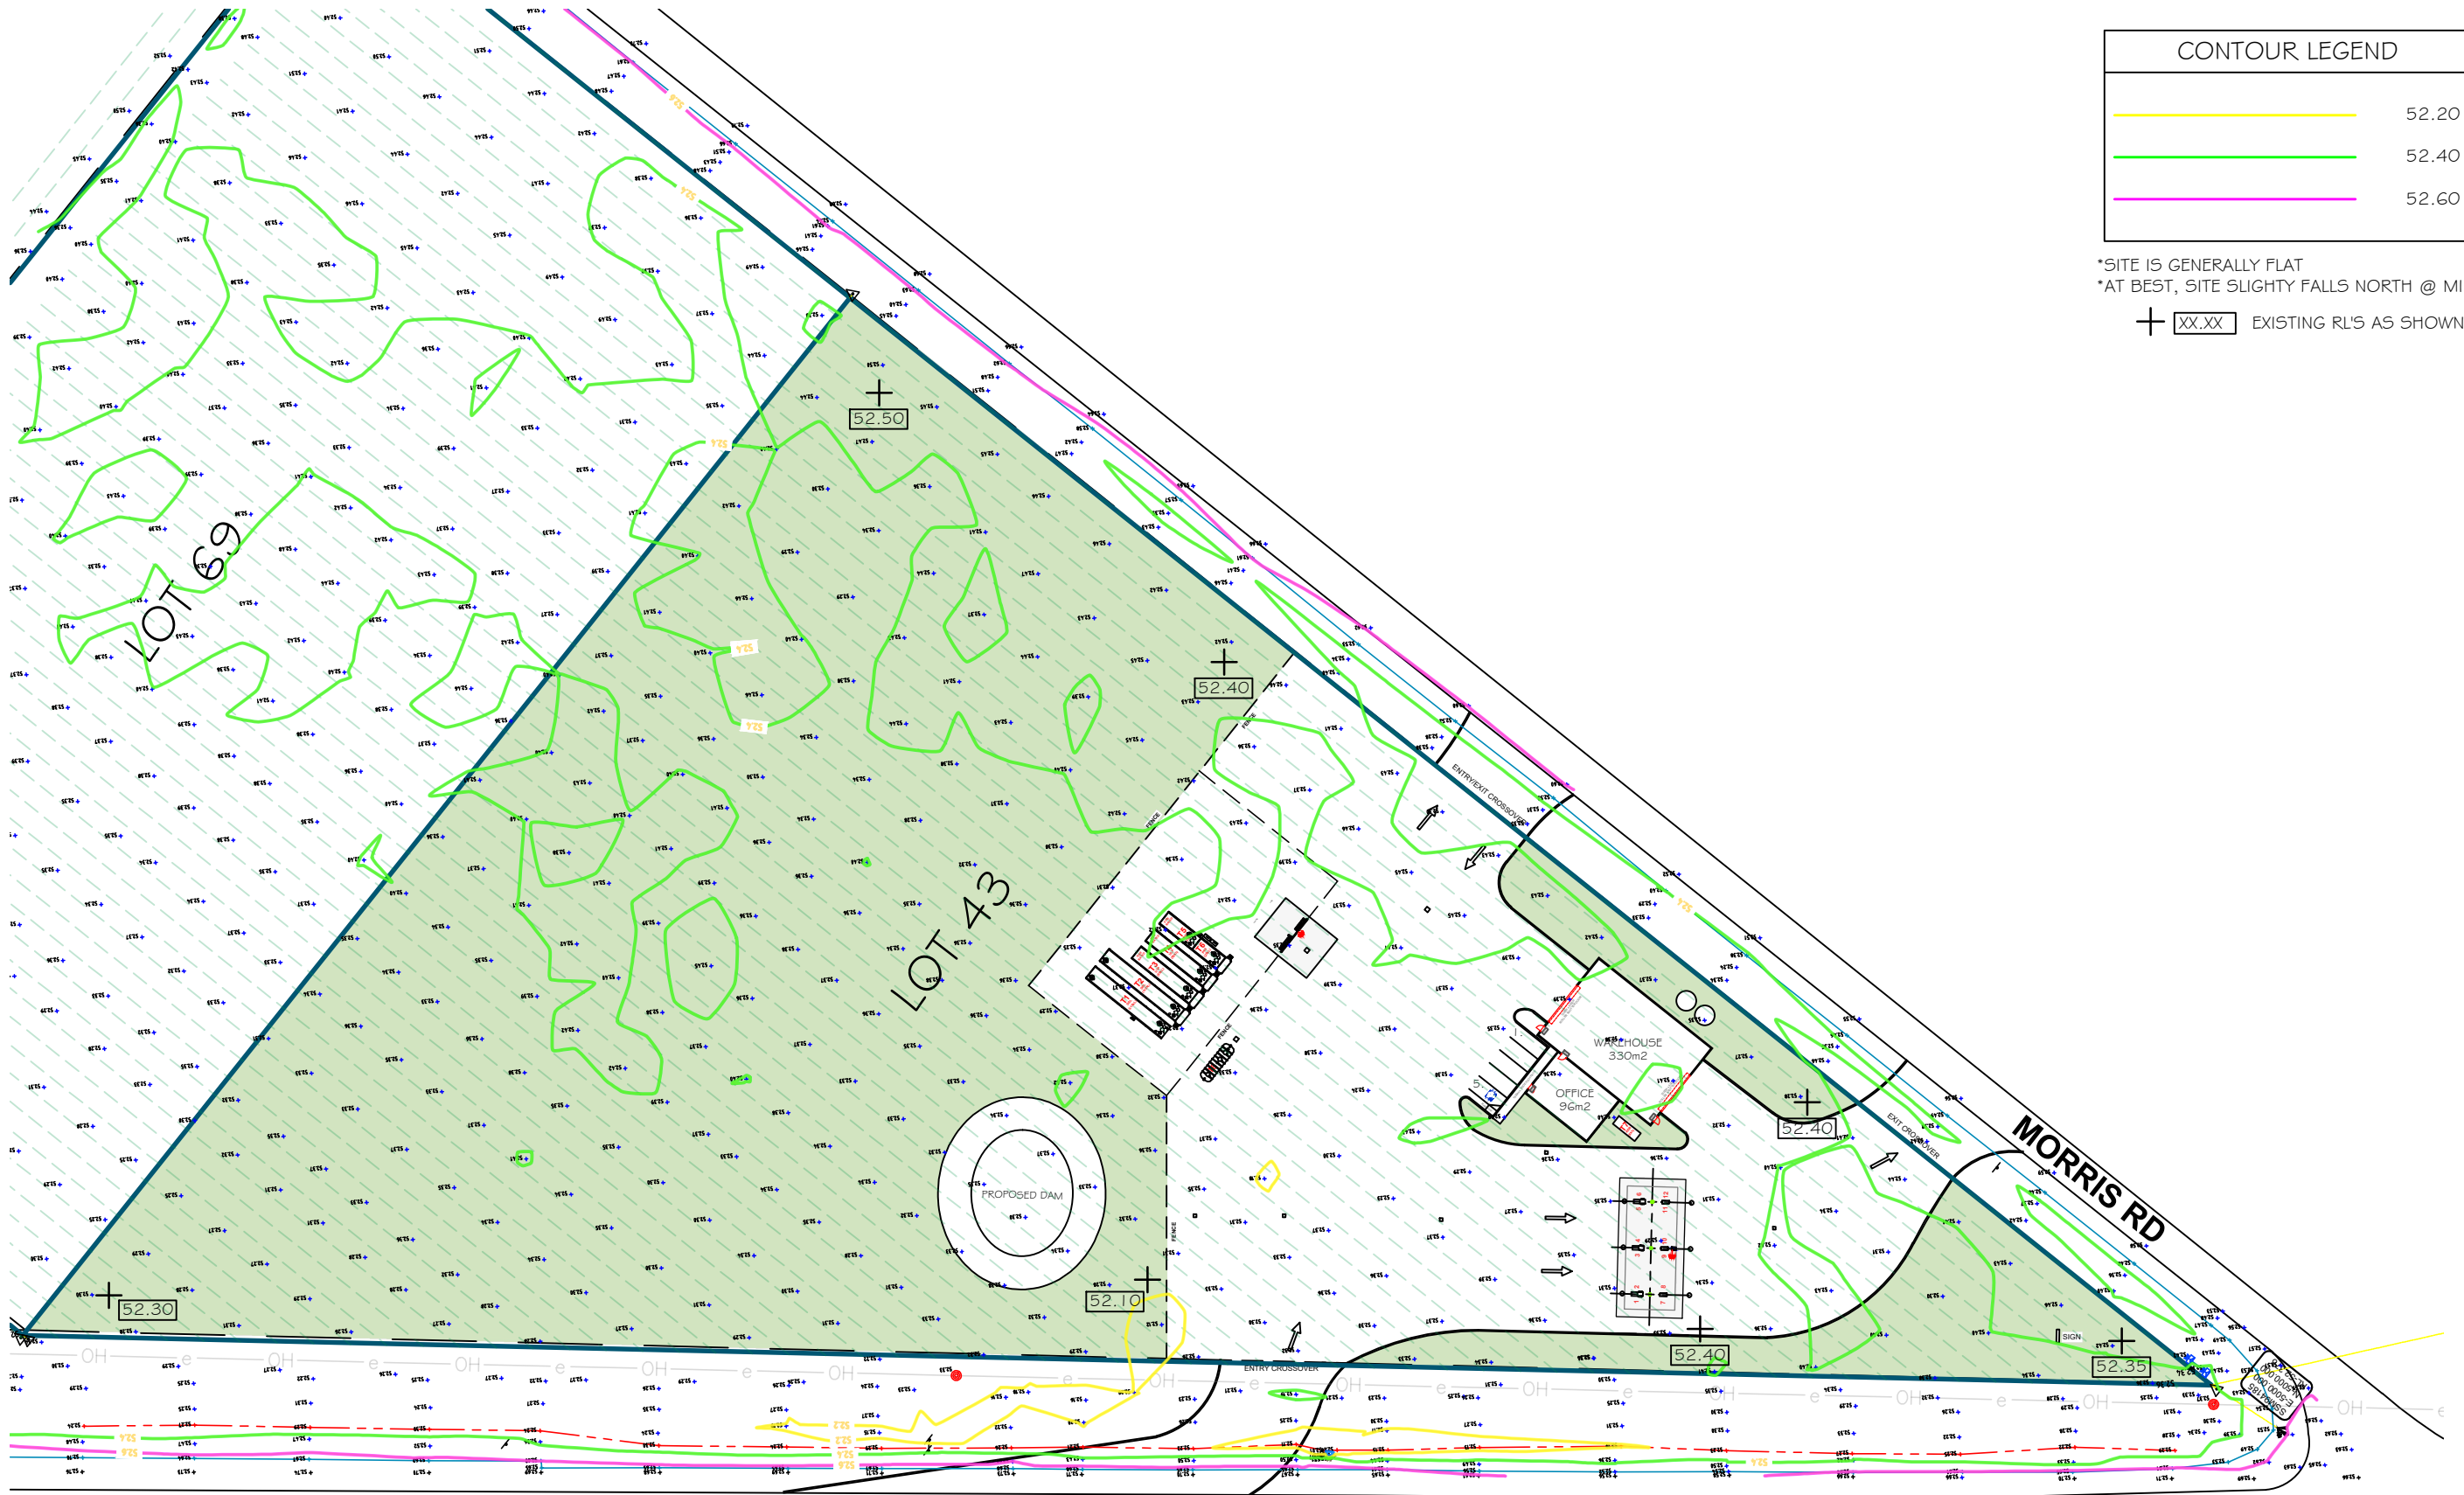


CONTOUR LEGEND	
	52.20
	52.40
	52.60

*SITE IS GENERALLY FLAT
*AT BEST, SITE SLIGHTLY FALLS NORTH @ MINOR GRADE
+ XX.XX EXISTING RL'S AS SHOWN

PROPOSED SITE LEVELS

SCALE 1:1000 @ A1 / 1:2000 @ A3

 PRELIMINARY
NOT FOR CONSTRUCTION



DO NOT SCALE
DIMENSIONS IN MM
DRAWING PRACTICE
TO AS1100

DWG No.	DATE	BY	REVISION/COMMENTS
1	17/11/22	TJB	ISSUED FOR COMMENT

BLACK DUCK DEVELOPMENTS
MOB: 0412 149 167
SUITE 6, 497 BURKE ROAD
HAWTHORN EAST VIC 3123


ABN : 68 086 502 838

DRAWN DATE NOV. 2022
DRAWN BY TJB
CLIENT SGH PETROLEUM

SGH PETROLEUM
CNR CAREY ST & MORRIS RD
EUSTON NSW 2737

PROPOSED SITE LEVELS

DRAWING No.	SIZE	REVISION
BD-SUNEUS-0802	A3	1

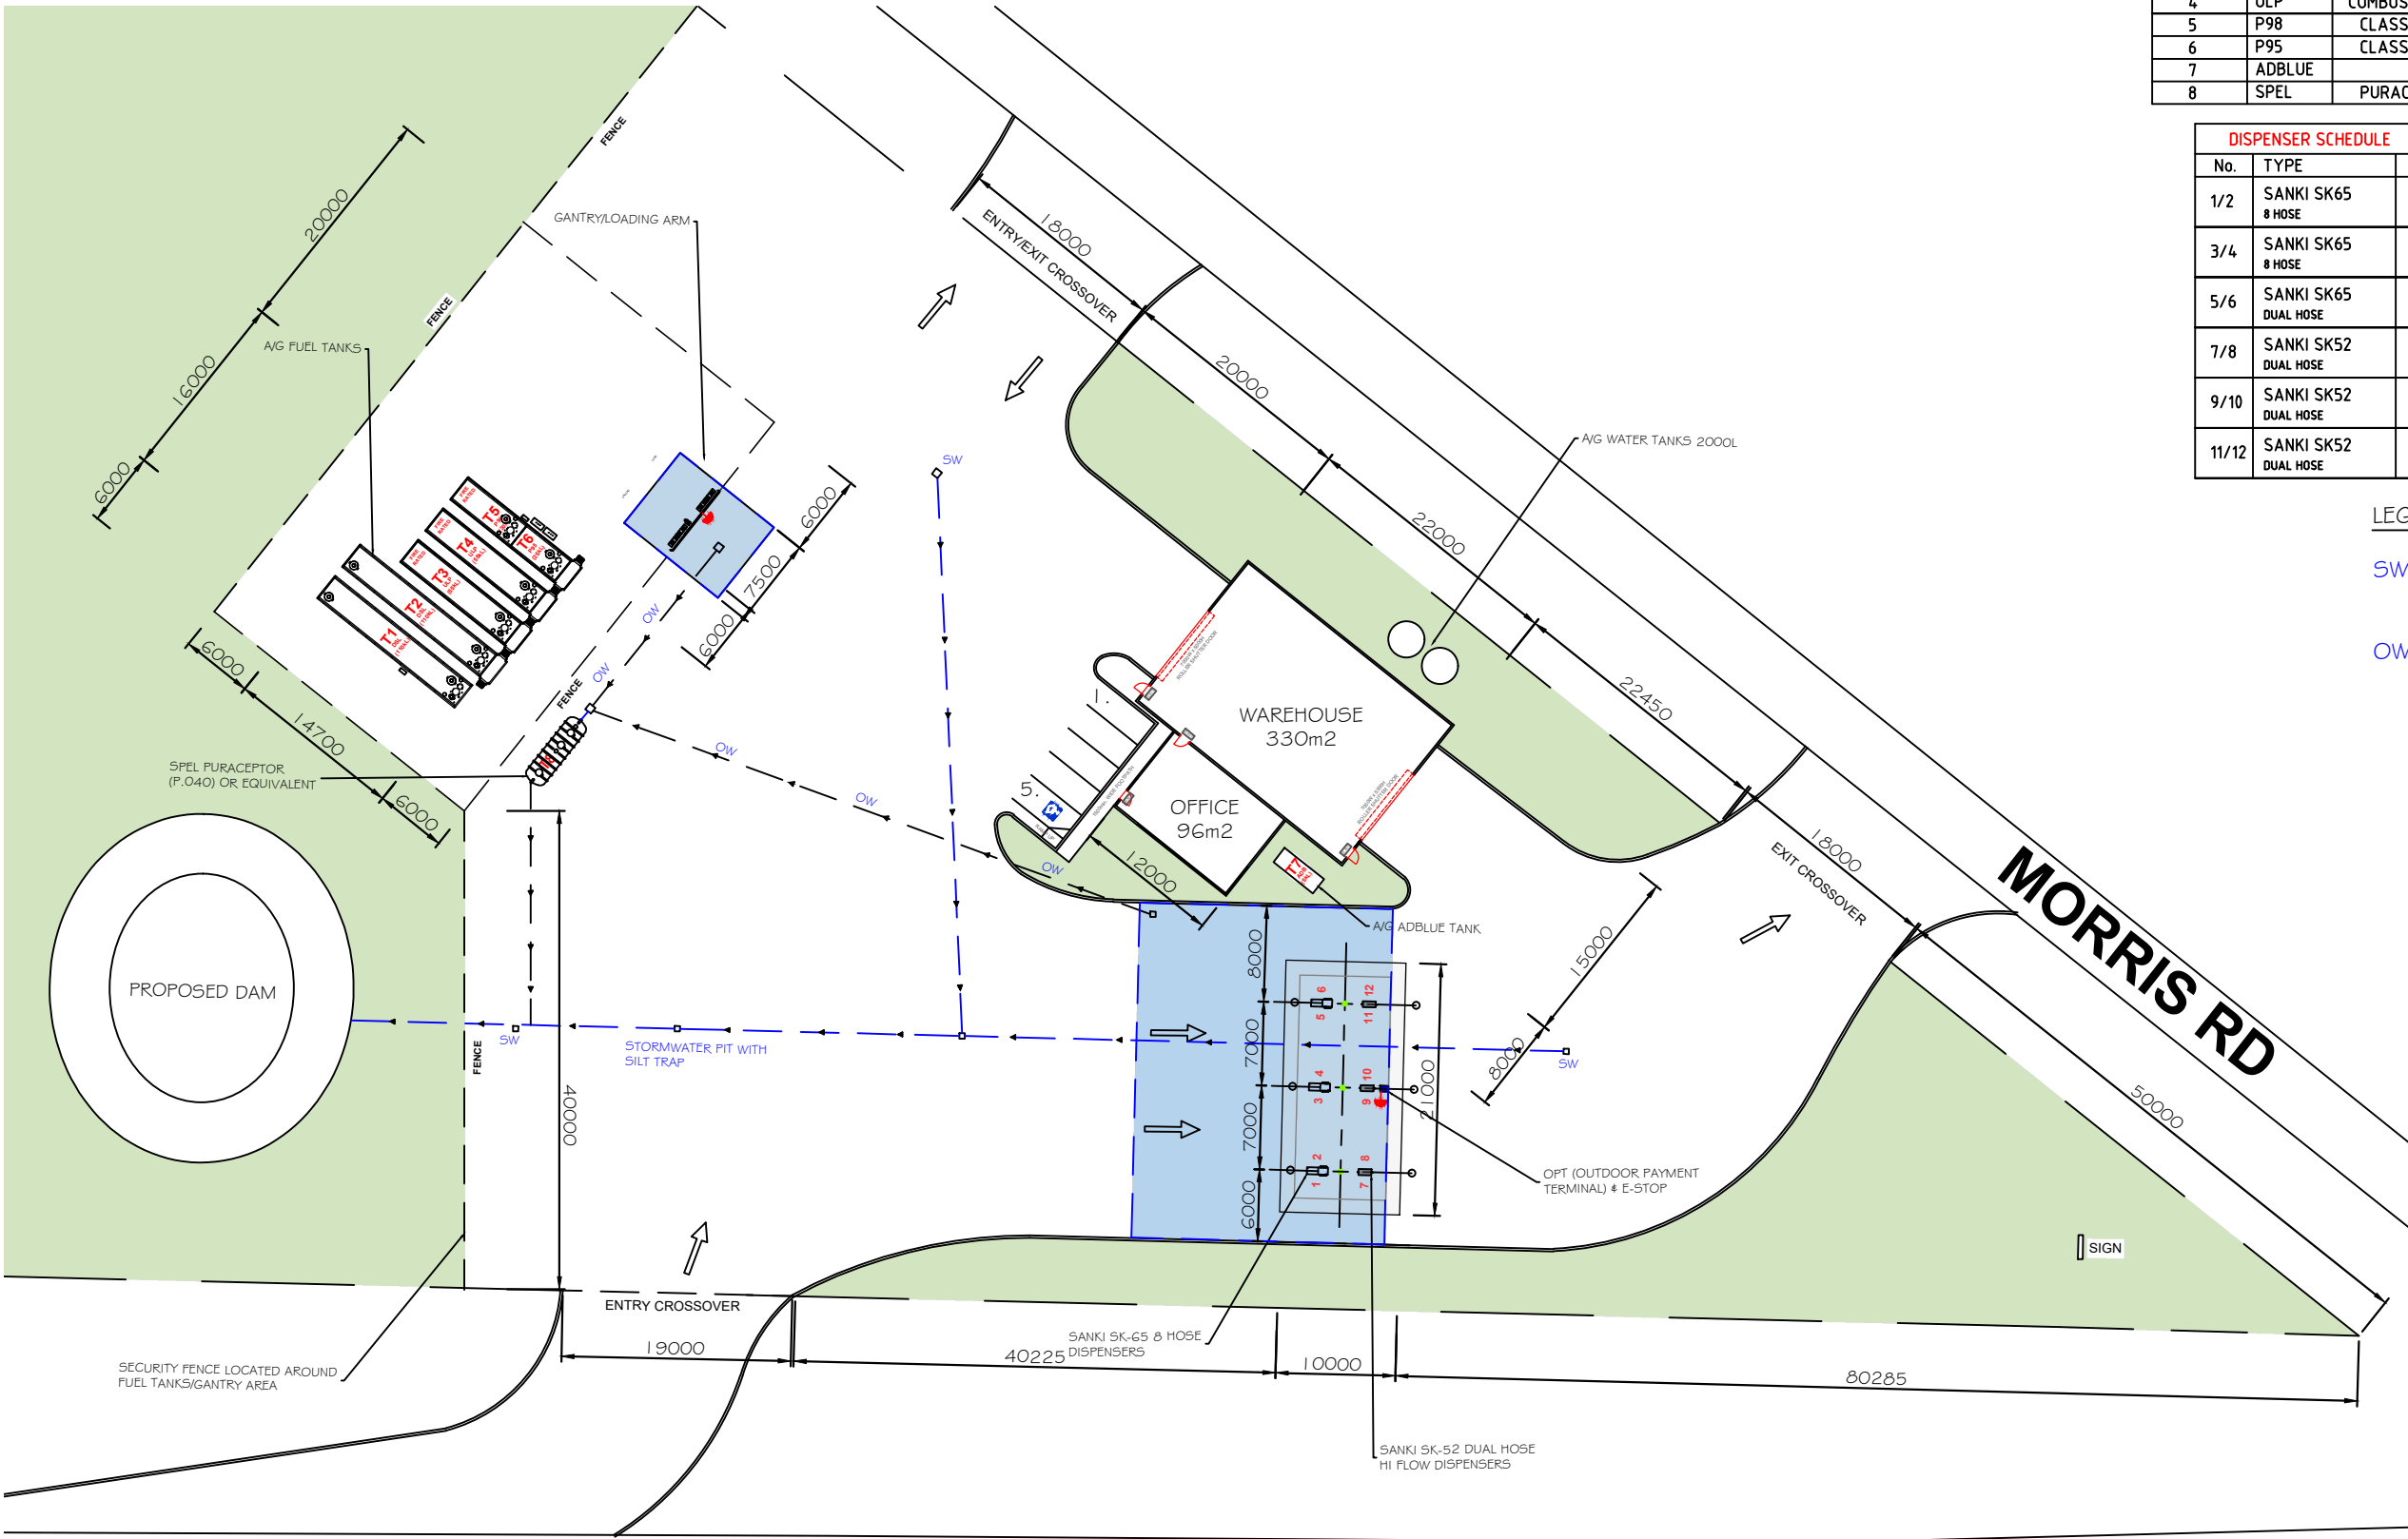

TANK SCHEDULE				
TANK No	PRODUCT	PROD. CLASS	DESCRIPTION	TANK CAP's Ltrs
1	DSL	CLASS 3 PG II	U/G SELF BUNDED TANKS	110,000
2	DSL	CLASS 3 PG II	U/G SELF BUNDED TANKS	110,000
3	ULP	CLASS 3 PG II	U/G SELF BUNDED TANKS	55,000
4	ULP	COMBUSTIBLE C1	U/G SELF BUNDED TANKS	54,000
5	P98	CLASS 3 PG II	U/G SELF BUNDED TANKS	30,000
6	P95	CLASS 3 PG II	U/G SELF BUNDED TANKS	25,000
7	ADBLUE		A/G SELF BUNDED TANKS	5,000
8	SPEL	PURACEPTOR	U/G SELF BUNDED TANK	5,000

DISPENSER SCHEDULE			
No.	TYPE	PRODUCT	COMMENT
1/2	SANKI SK65 8 HOSE	ULP/P95 P98/DSL	NEW MPD REFER TO HOSE LOCATION ORDER
3/4	SANKI SK65 8 HOSE	ULP/P95 P98/DSL	NEW MPD REFER TO HOSE LOCATION ORDER
5/6	SANKI SK65 DUAL HOSE	ULP/P95 P98/DSL	NEW MPD REFER TO HOSE LOCATION ORDER
7/8	SANKI SK52 DUAL HOSE	DSL/ADB	NEW MPD - 110 LPM REFER TO HOSE LOCATION ORDER
9/10	SANKI SK52 DUAL HOSE	DSL/ADB	NEW MPD - 110 LPM REFER TO HOSE LOCATION ORDER
11/12	SANKI SK52 DUAL HOSE	DSL/ADB	NEW MPD - 110 LPM REFER TO HOSE LOCATION ORDER

LEGEND

SW = STORMWATER PIT 600 X 600 WITH GRATED LID

OW = OIL WATER PIT 600 X 600 WITH GRATED LID TO RUN TO SPEL PURACEPTOR


ALL PAVEMENT RUNOFF TO RUN TO PROPOSED DAM

STURT HWY

FUEL DRAINAGE LAYOUT

SCALE 1:600 @ A3

 PRELIMINARY
NOT FOR CONSTRUCTION




DO NOT SCALE DIMENSIONS IN MM DRAWING PRACTICE TO AS1100			
DWG No.	DATE	BY	REVISION/COMMENTS
1	17/11/22	TJB	ISSUED FOR COMMENT


BLACK DUCK DEVELOPMENTS		
MOB: 0412 149 167 SUITE 6, 497 BURKE ROAD HAWTHORN EAST VIC 3123		
ABN : 68 086 502 838		
DRAWN DATE NOV. 2022	DRAWN BY TJB	CLIENT SGH PETROLEUM

SGH PETROLEUM
CNR CAREY ST & MORRIS RD
EUSTON NSW 2737


FUEL DRAINAGE LAYOUT		
DRAWING No.	SIZE	REVISION
BD-SUNEUS-1401	A3	1

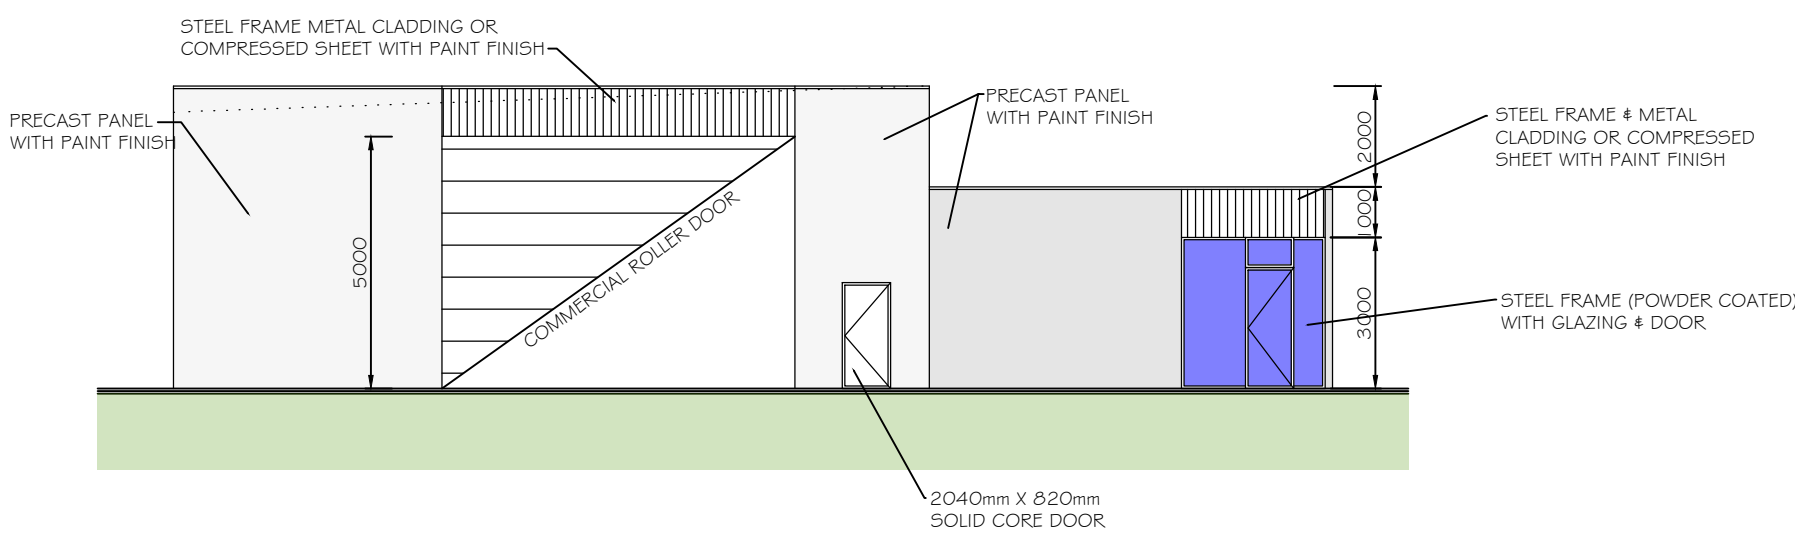


NORTH ELEVATION

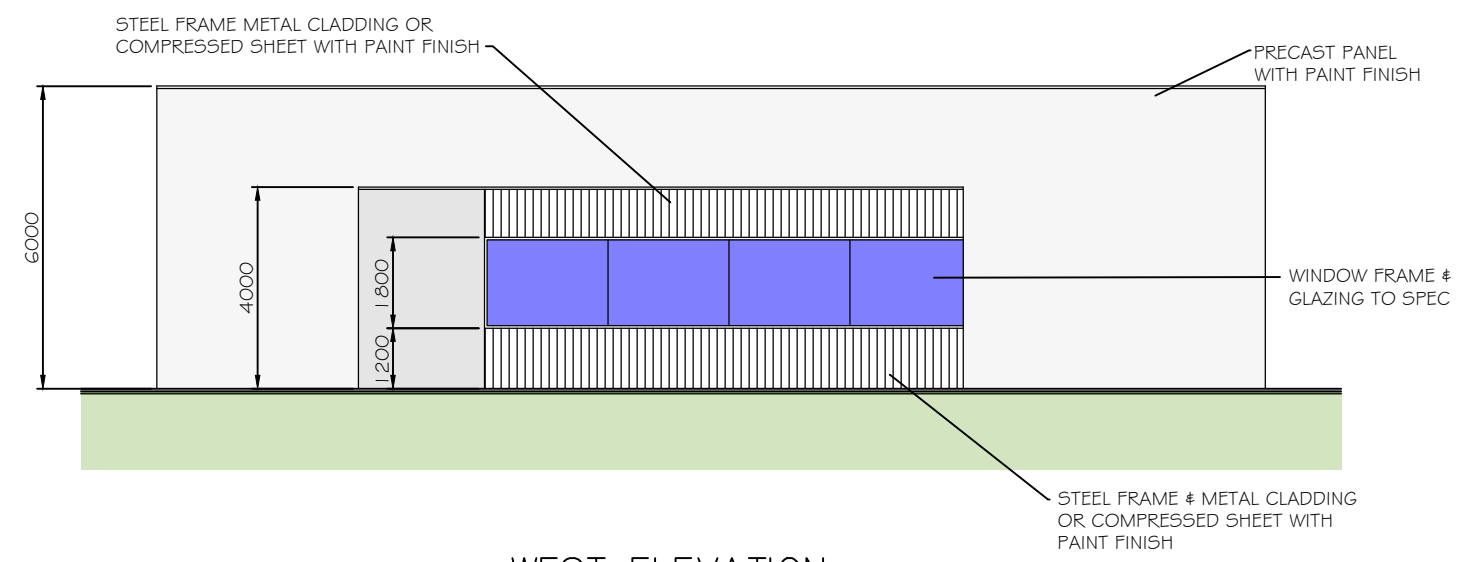


WEST ELEVATION

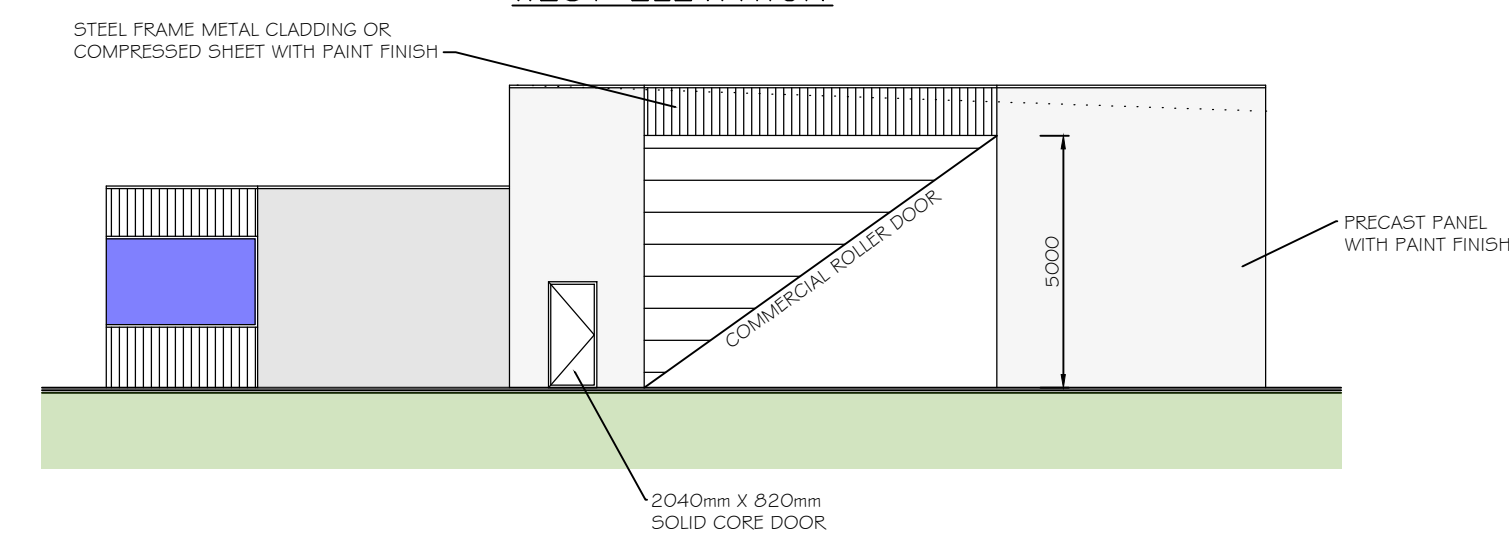


SOUTH ELEVATION

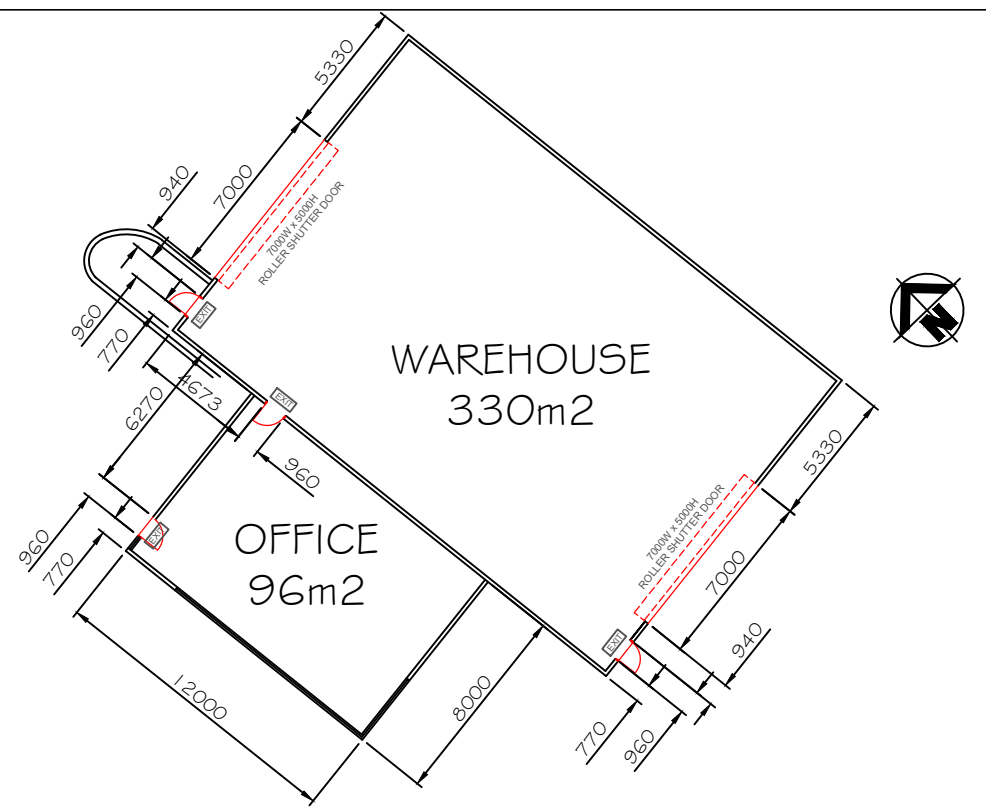

WAREHOUSE LAYOUT

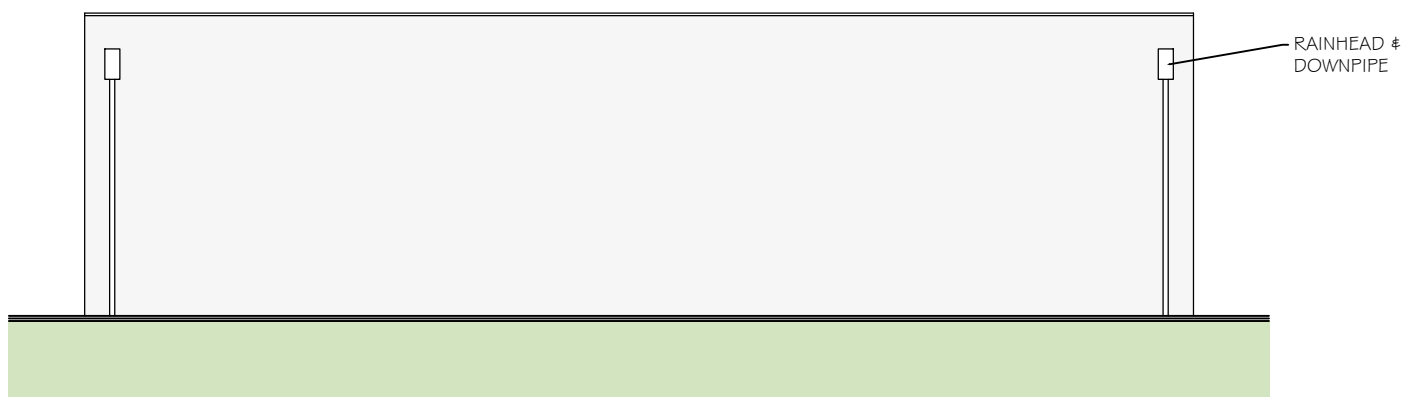

EAST ELEVATION

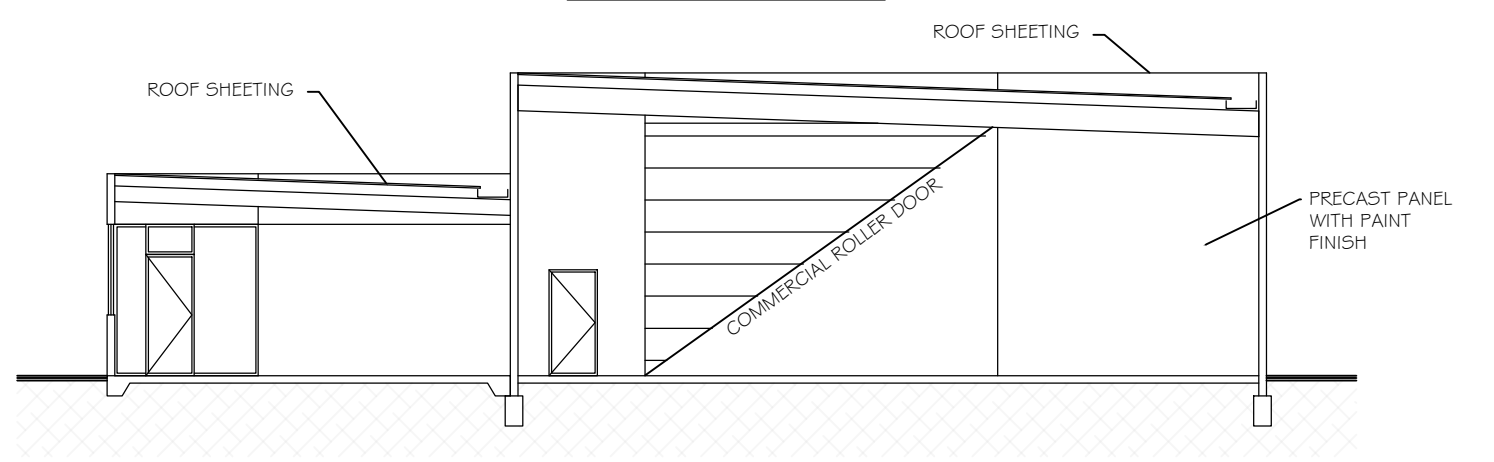


SECTION 1 - 1


WAREHOUSE - OFFICE ELEVATIONS

SCALE : VARIES


ALL FUEL SYSTEM WORKS TO BE DESIGNED,
CERTIFIED & INSTALLED BY EXPERIENCED,
COMPETENT & ACCREDITED PERSONS.
ALL WORKS TO CURRENT AUSTRALIAN CODE
& STANDARDS

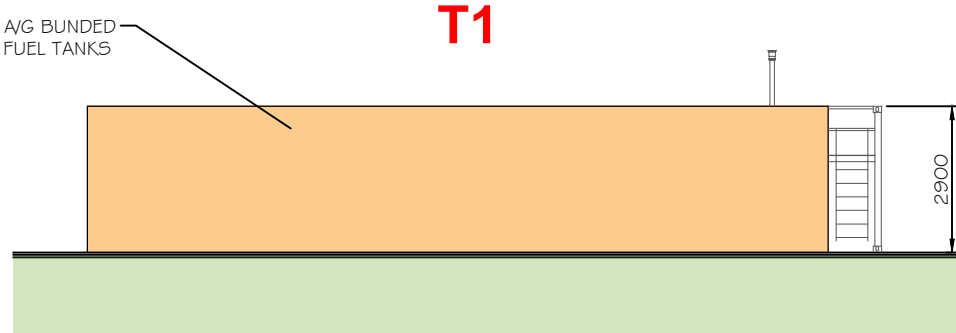


SIDE ELEVATION A

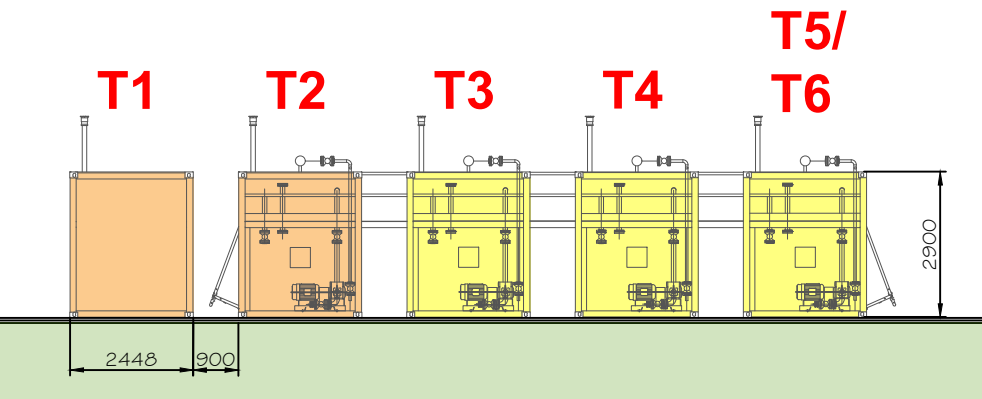

FRONT ELEVATION

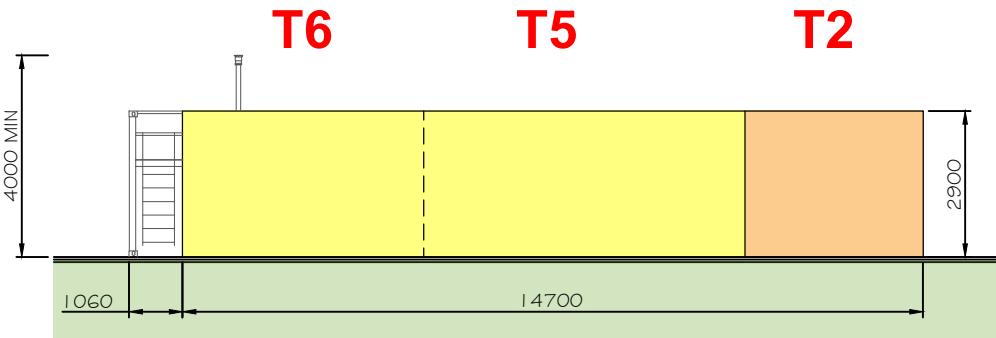


SIDE ELEVATION B

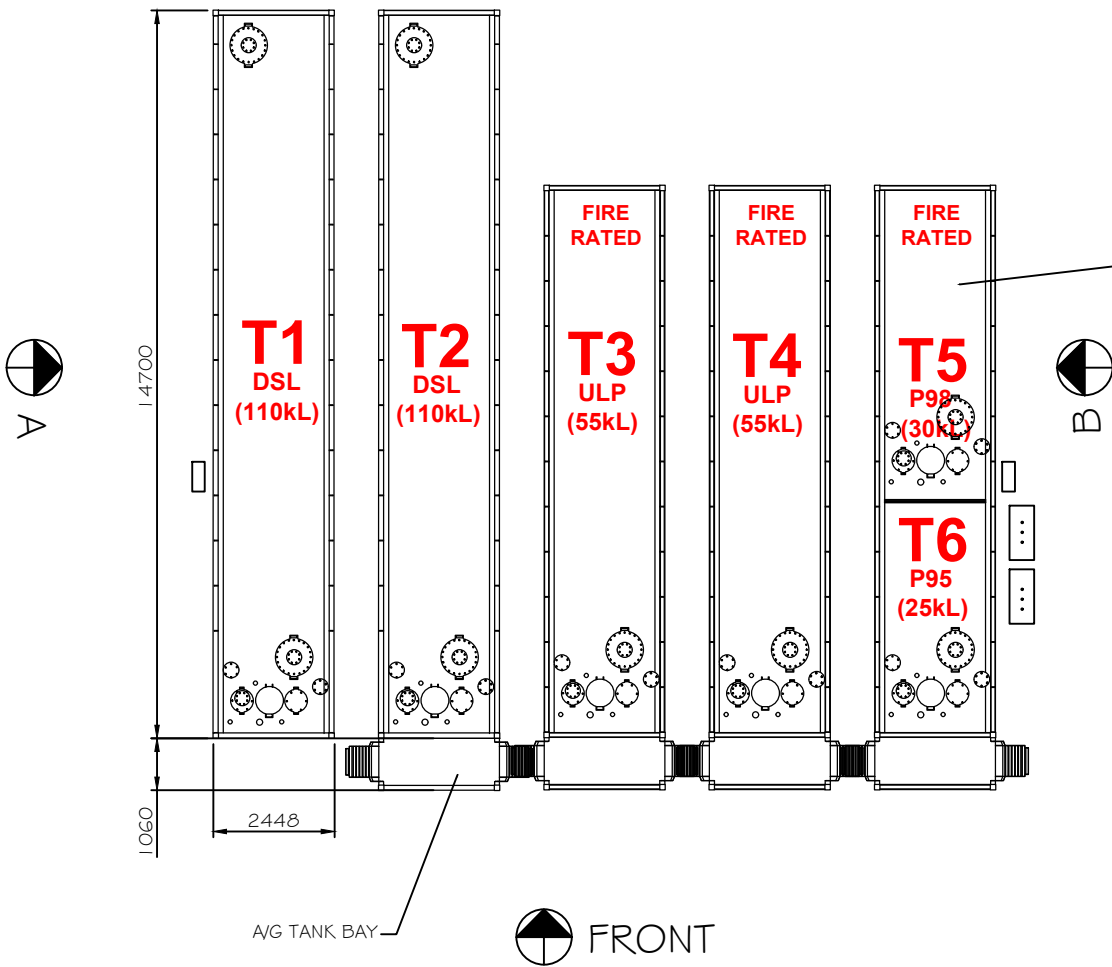

FENCE

TANK FARM LAYOUT

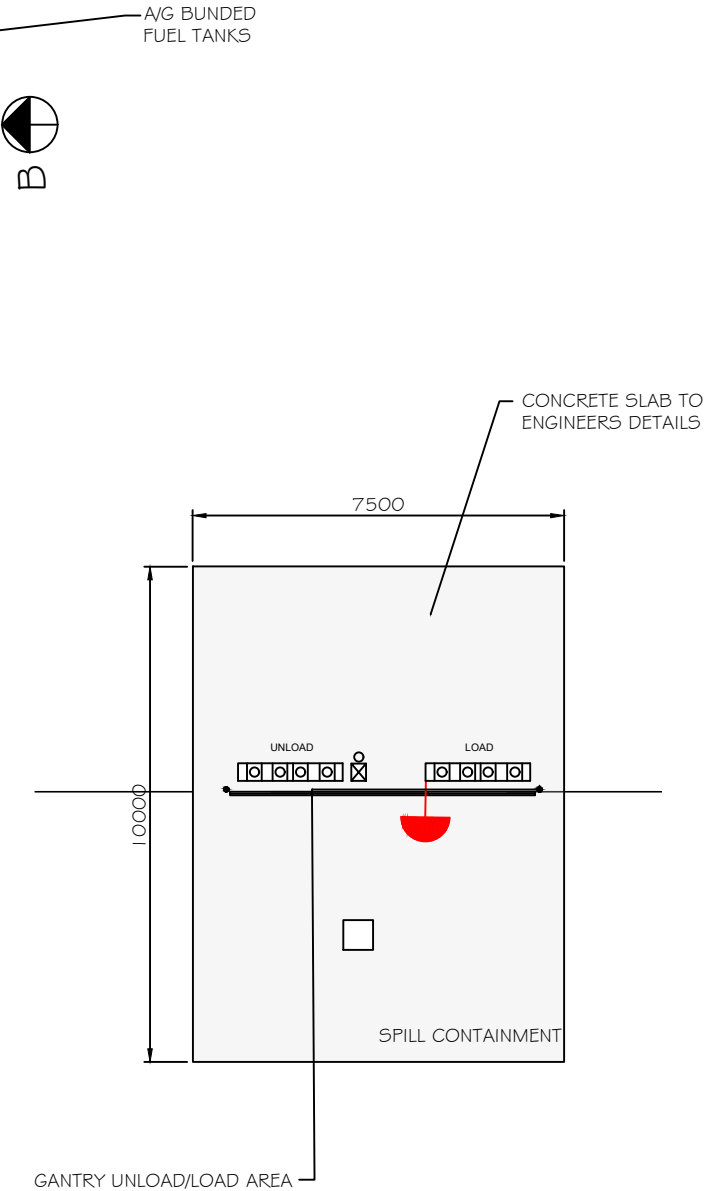

TANK FARM DETAILS & ELEVATIONS

SCALE : VARIES

PRELIMINARY
NOT FOR CONSTRUCTION




DO NOT SCALE
DIMENSIONS IN MM
DRAWING PRACTICE
TO AS1100

DWG. No.	DATE	BY	REVISION/COMMENTS
1	17/11/22	TJB	ISSUED FOR COMMENT


BLACK DUCK DEVELOPMENTS		
MOB: 0412 149 167		
SUITE 6, 497 BURKE ROAD		
HAWTHORN EAST VIC 3123		
ABN : 68 086 502 838		
DRAWN DATE	DRAWN BY	CLIENT
NOV. 2022	TJB	SGH PETROLEUM

SGH PETROLEUM
CNR CAREY ST & MORRIS RD
EUSTON NSW 2737


TANK FARM DETAILS		
DRAWING No.	SIZE	REVISION
BD-SUNEUS-0904	A3	1

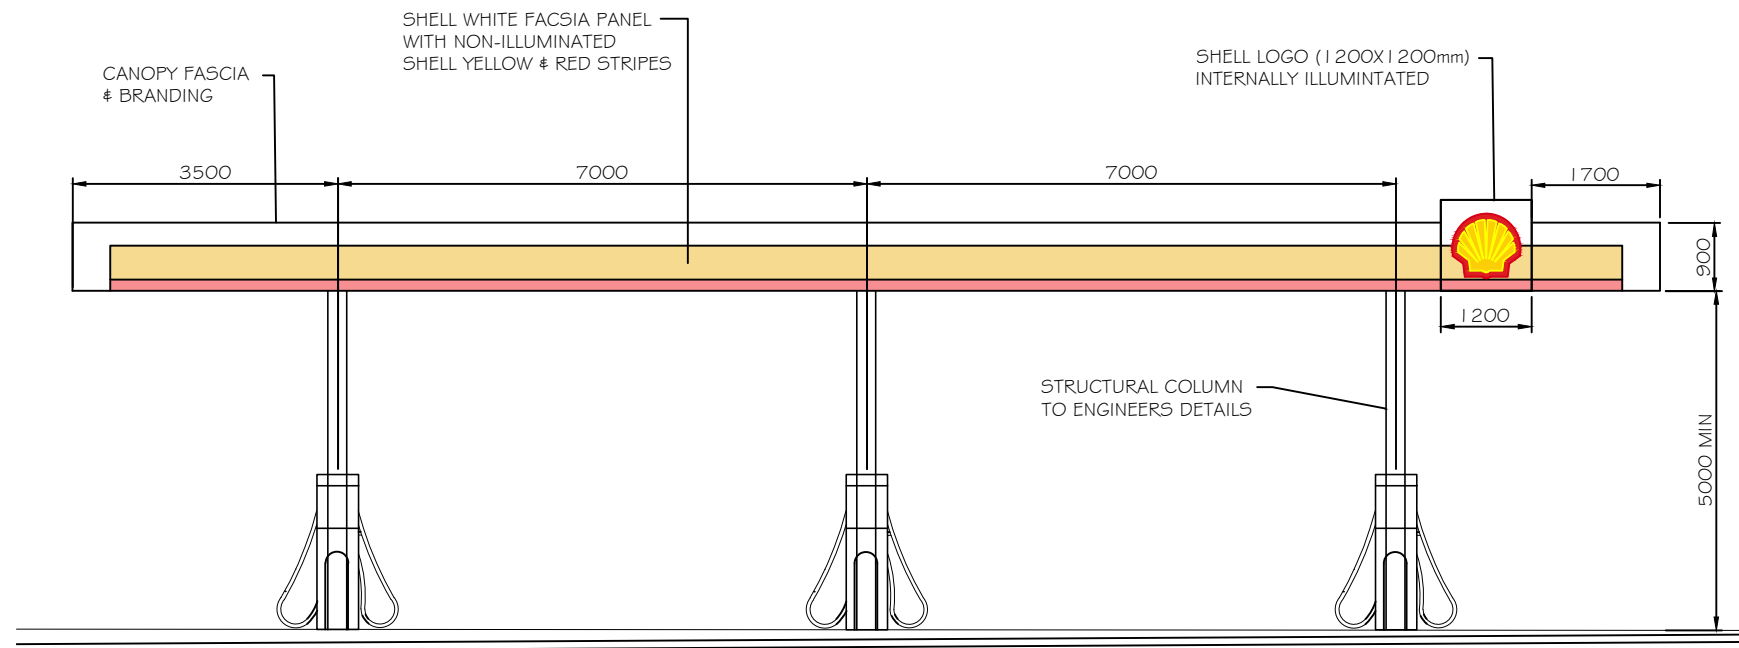

CANOPY SIDE ELEVATION A

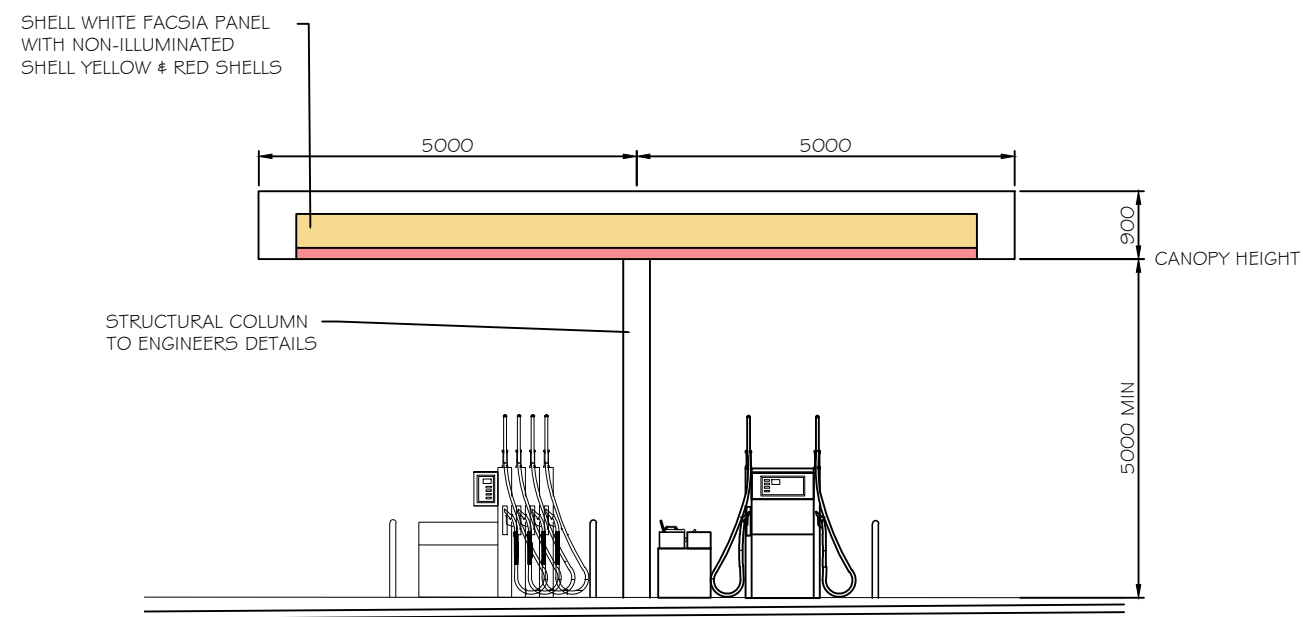

CANOPY SIDE ELEVATION B

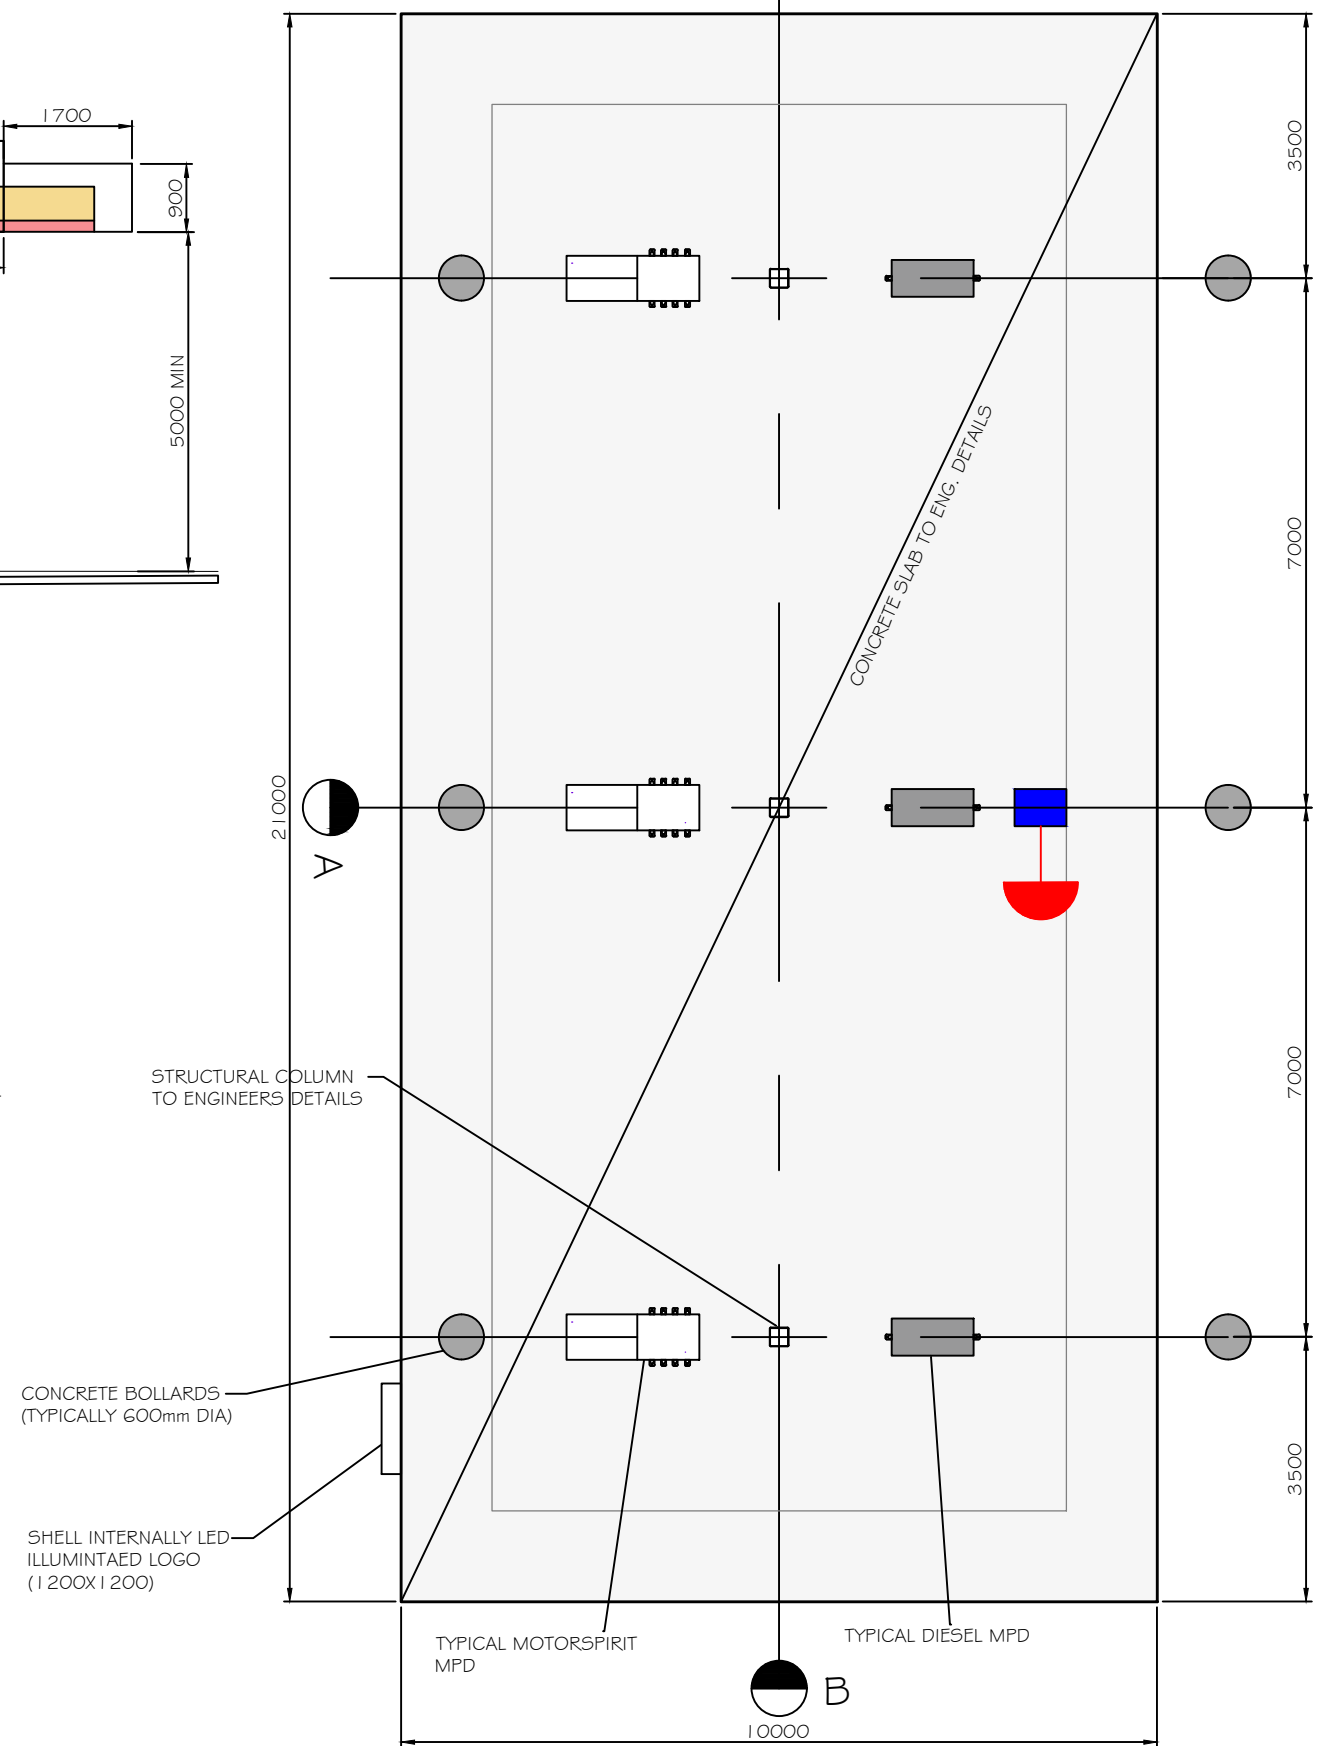

CANOPY LAYOUT

CANOPY DETAILS & ELEVATIONS

SCALE : VARIES

PRELIMINARY
NOT FOR CONSTRUCTION



DO NOT SCALE
DIMENSIONS IN MM
DRAWING PRACTICE
TO AS1100

DWG. No.	DATE	BY	REVISION/COMMENTS
1	17/11/22	TJB	ISSUED FOR COMMENT

BLACK DUCK DEVELOPMENTS
MOB: 0412 149 167
SUITE 6, 497 BURKE ROAD
HAWTHORN EAST VIC 3123

DRAWN DATE
NOV. 2022

DRAWN BY
TJB

CLIENT

SGH PETROLEUM
ABN : 68 086 502 838

SGH PETROLEUM
CNR CAREY ST & MORRIS RD
EUSTON NSW 2737

CANOPY DETAILS

DRAWING No.	SIZE	REVISION
BD-SUNEUS-0903	A3	1

